


THE DESIGN AND DETAILS DISCLOSED HEREIN ARE THE EXCLUSIVE PROPERTY OF CARLIN MANUFACTURING LLC AND SHALL NOT BE COPIED OR REPRODUCED IN ANY MANNER WITHOUT THE PRIOR WRITTEN CONSENT OF CARLIN MANUFACTURING LLC.

ZONE	REV	DESCRIPTION	DATE	APPROVED
A		MIXER DELETED	02/02/05	

<b>Kitchens To Go</b>		FOR THE CUSTOMER'S USE ONLY DO NOT SCALE DIMENSIONS	
UNIT NO.	583-554A01-0-01	PROJECT NO.	583-554A01-0-01
DATE	3/16/05	SCALE	1" = 1'-0"
<b>CAMP PEARY</b>		DRAWING NUMBER: 583-554A01-0-01	
REV	A	DATE	3/16/05


UNIT NO.	CC553-554	DATE	3/16/05
PROJECT NO.	583-554A01-0-01	SCALE	1" = 1'-0"
<b>FLOOR PLAN AND EQUIPMENT LIST</b>		DRAWING NUMBER: 583-554A01-0-01	
REV	A	DATE	3/16/05

- EQUIPMENT LIST:
- 3 COMPARTMENT SINK
  - HAND SINK WITH SOAP
  - WATER HEATER
  - ELECTRICAL PANEL
  - ENTRY DOOR
  - WORK TABLE (2EA)
  - NOT USED
  - DRY STORAGE
  - WALK-IN FREEZER
  - WALK-IN REFRIGERATOR
  - HVAC UNIT
  - STAINLESS STEEL HOOD
  - DUAL STACKED CONVECTION OVEN
  - 40 GAL STEAM KETTLE
  - 36" COUNTERTOP GRIDDLE
  - 36" RANGE WITH STANDARD OVEN BELOW
  - FIRE SUPPRESSION SYSTEM
  - POT RACK

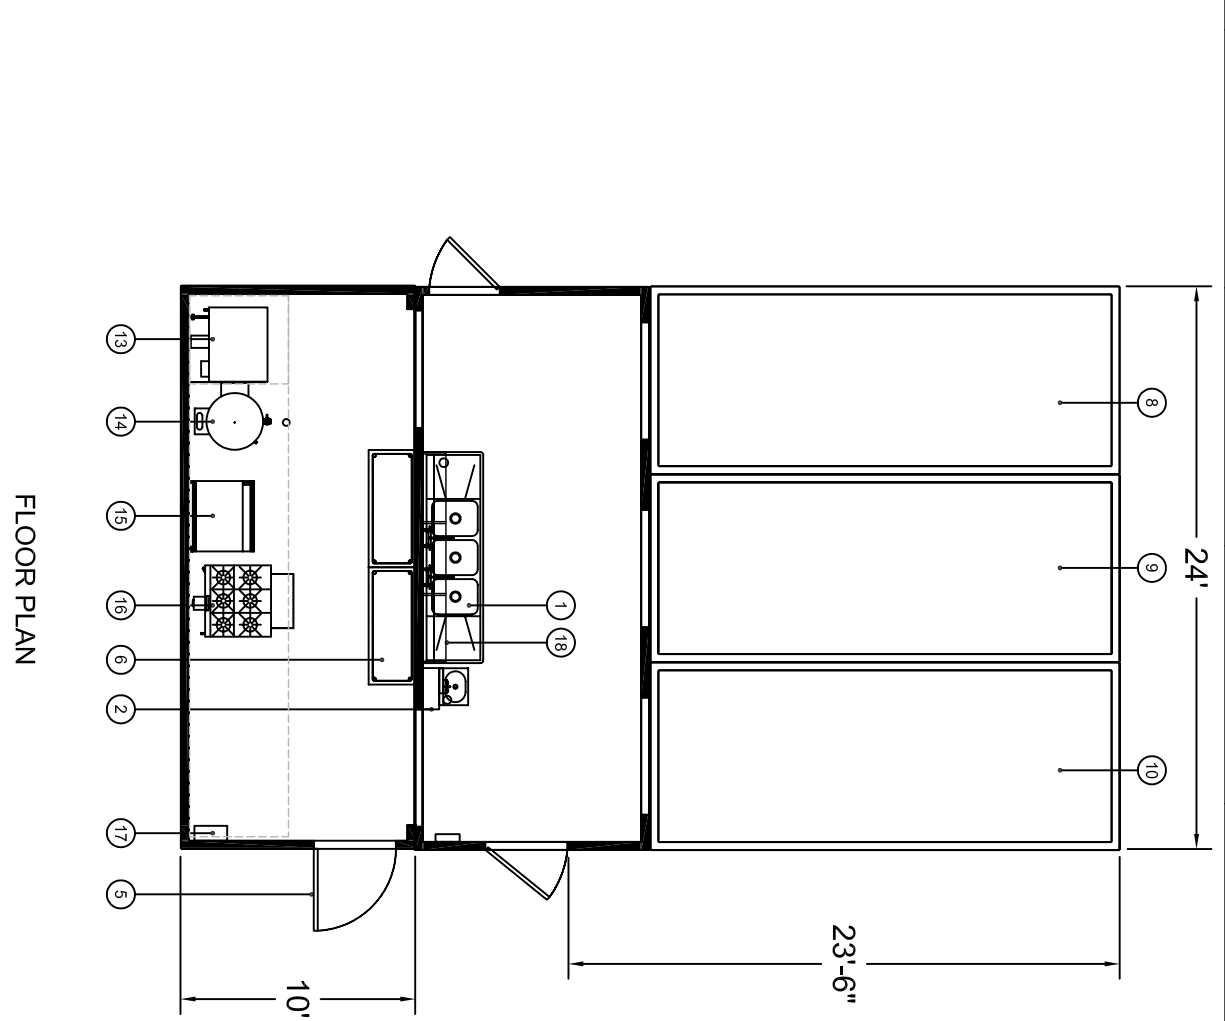

APPROVED  
BY CLIENT

BY \_\_\_\_\_ DATE \_\_\_\_\_

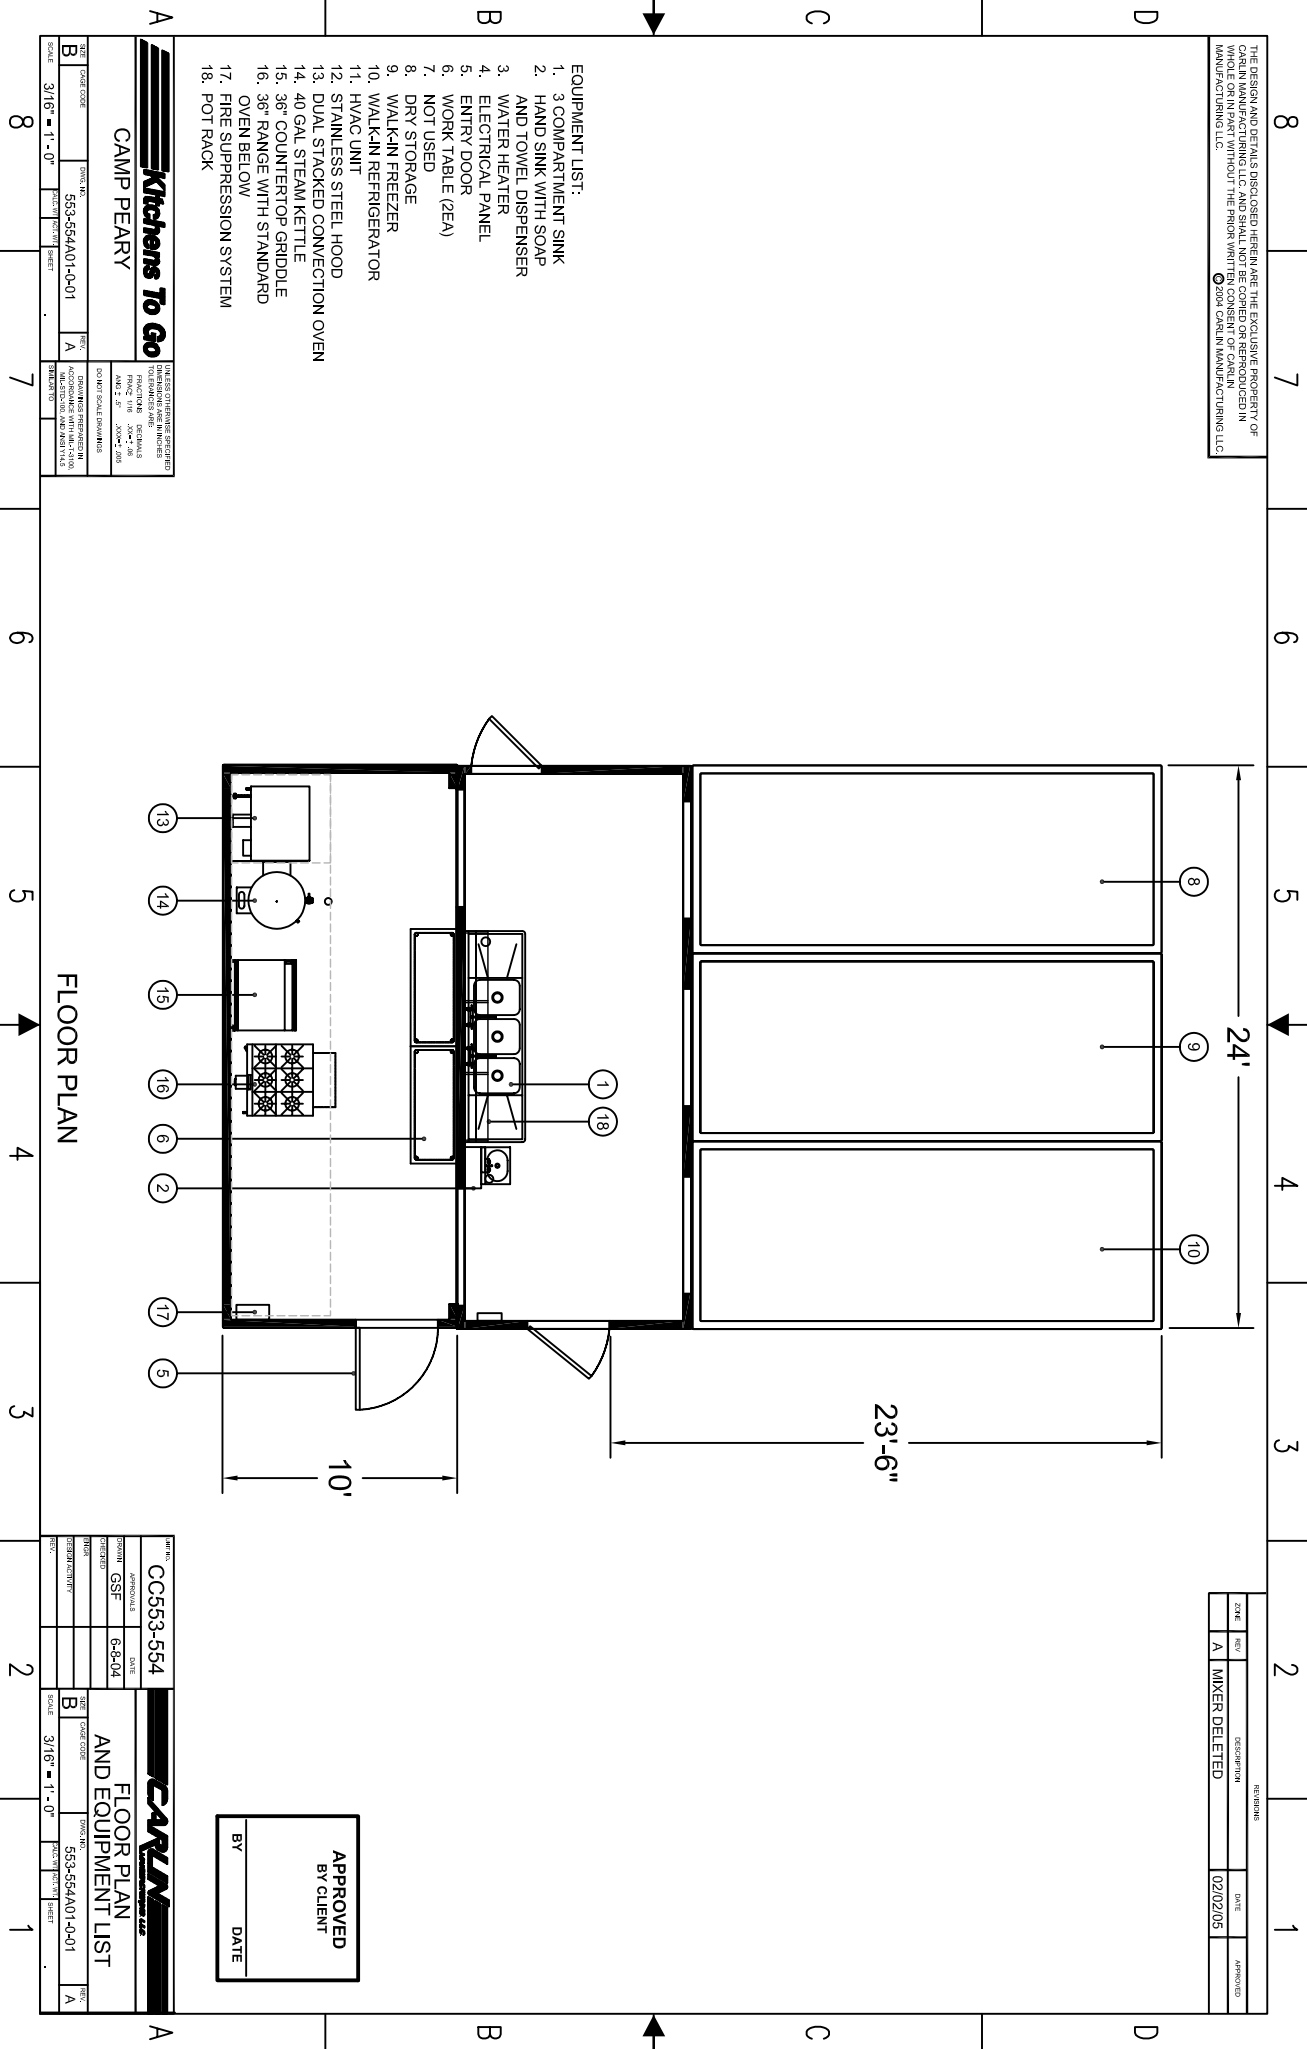

FLOOR PLAN