


THE DESIGN AND DETAILS DISCLOSED HEREIN ARE THE EXCLUSIVE PROPERTY OF CARLIN MANUFACTURING, LLC, AND SHALL NOT BE COPIED OR REPRODUCED IN WHOLE OR IN PART WITHOUT THE PRIOR WRITTEN CONSENT OF CARLIN MANUFACTURING, LLC. © 2005 CARLIN MANUFACTURING, LLC.

REVISIONS			
ZONE	REV	DATE	APPROVED

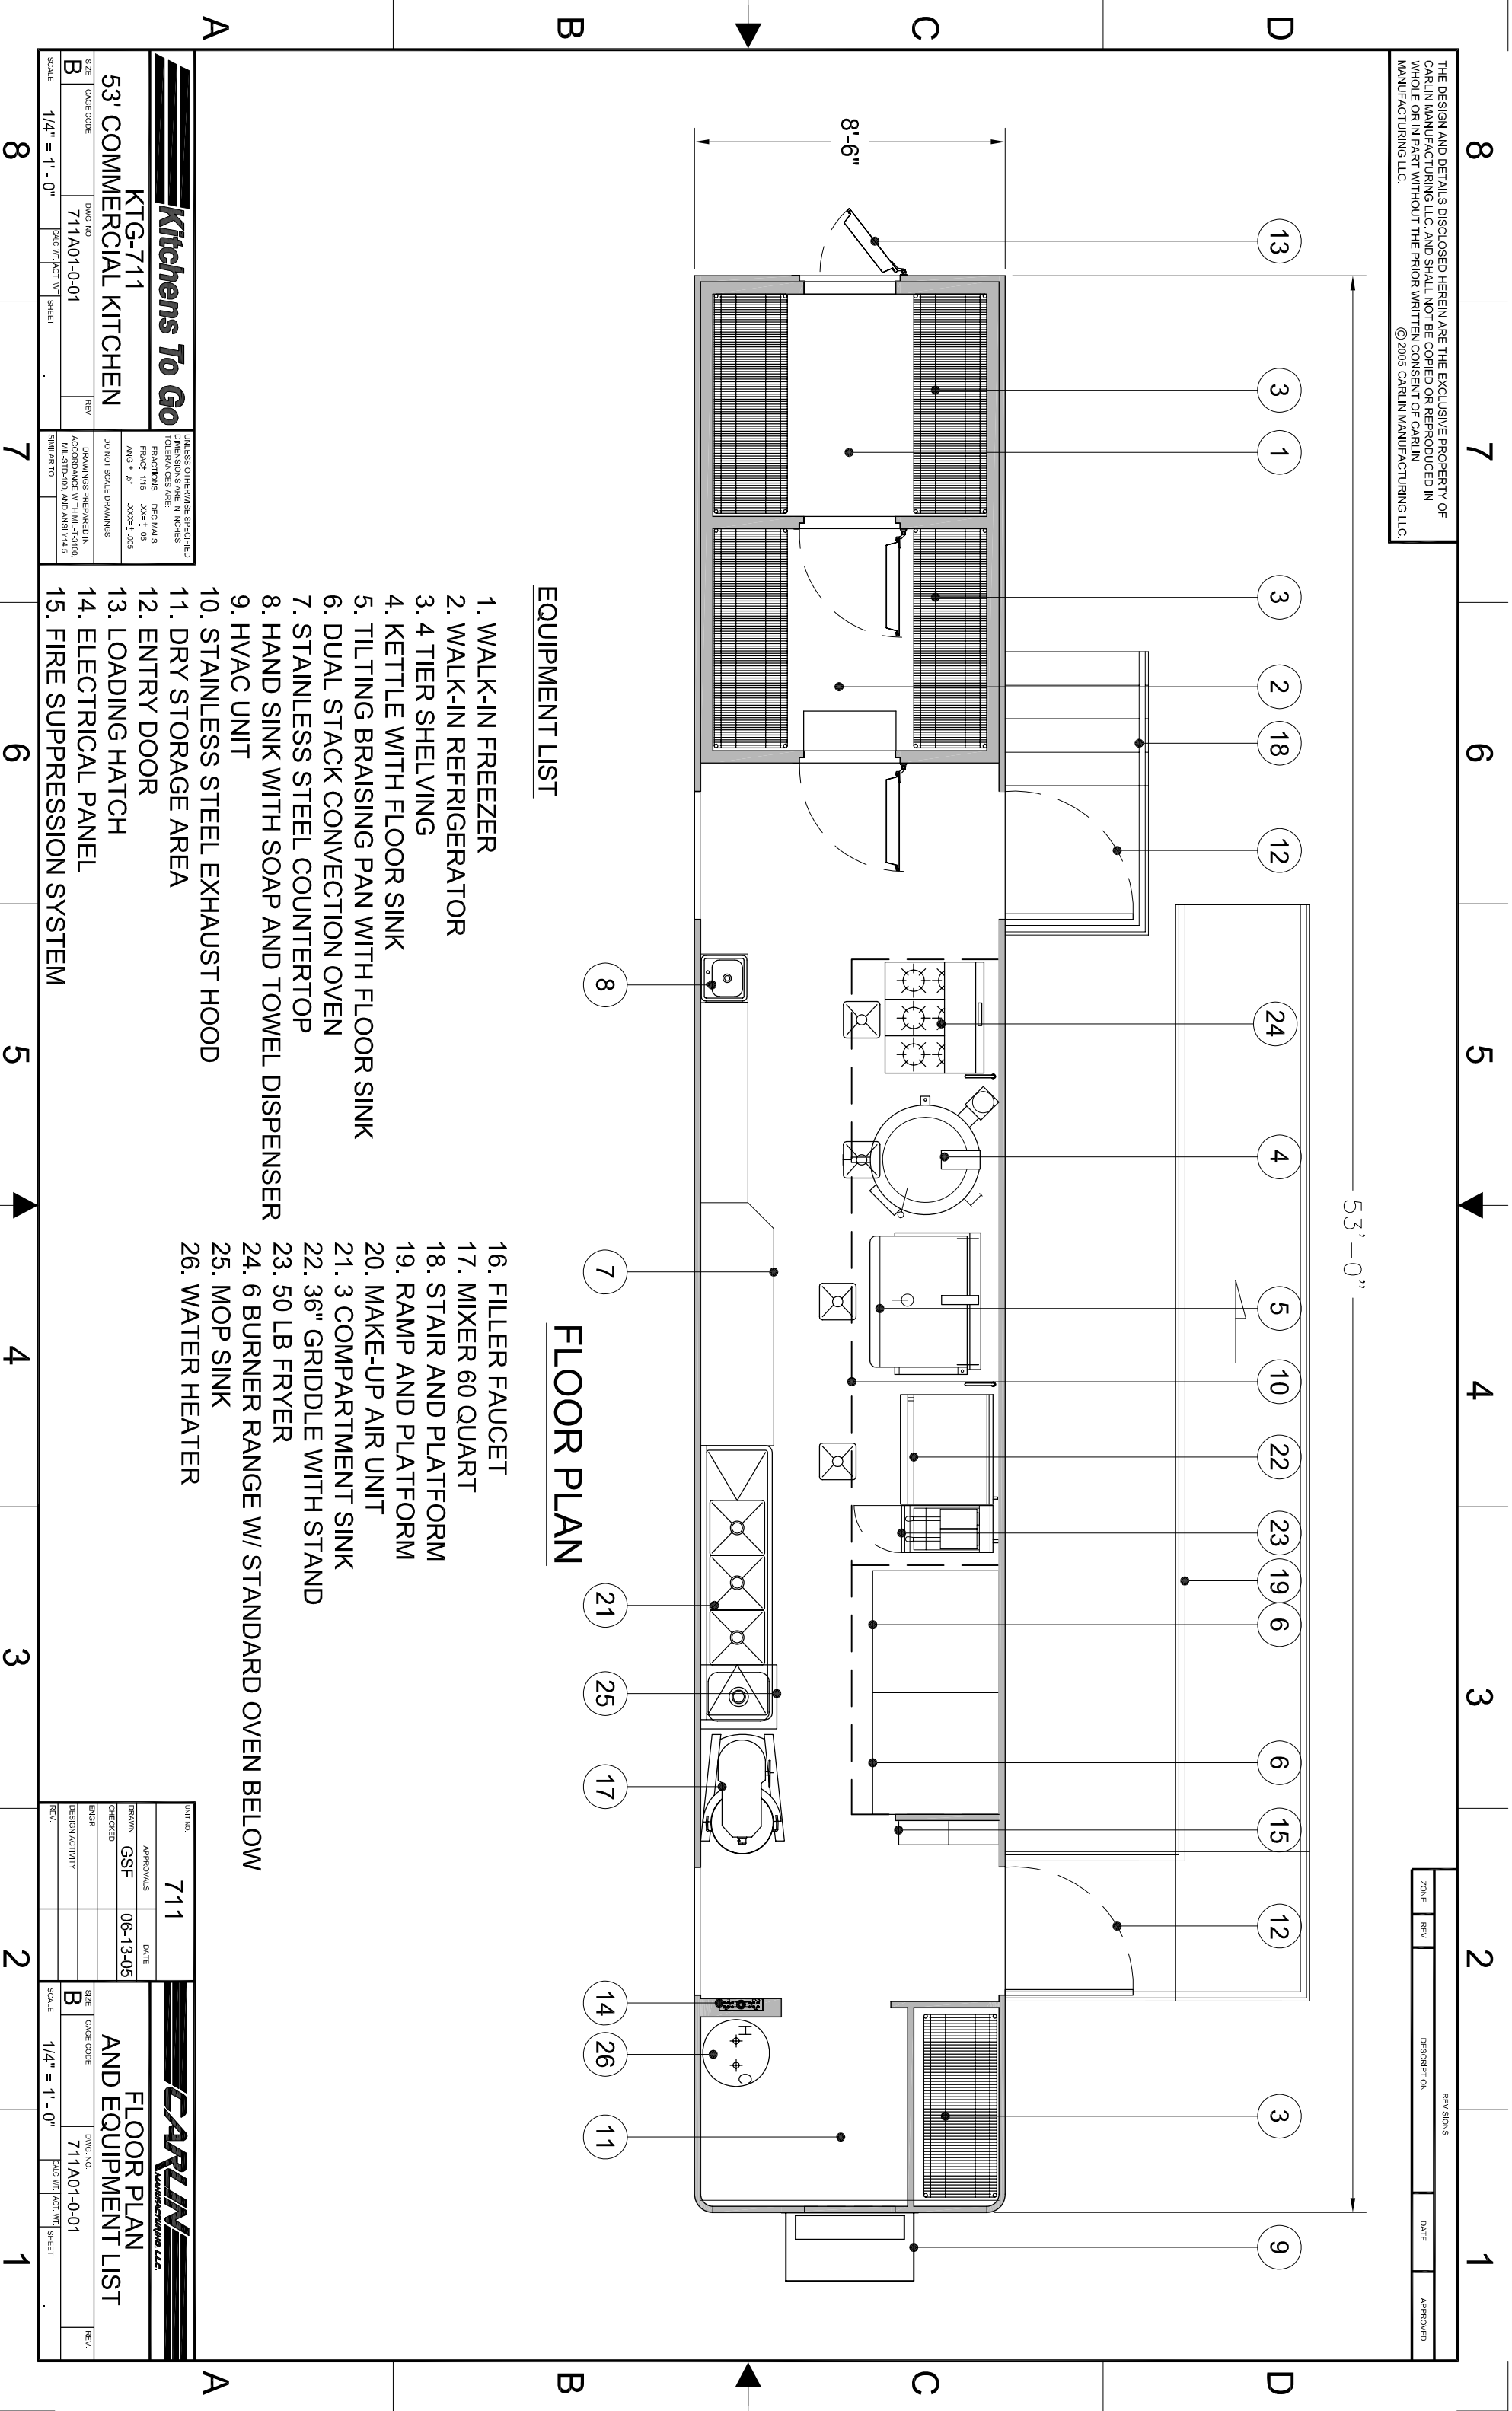

**EQUIPMENT LIST**

1. WALK-IN FREEZER
2. WALK-IN REFRIGERATOR
3. 4 TIER SHELVING
4. KETTLE WITH FLOOR SINK
5. TILTING BRAISING PAN WITH FLOOR SINK
6. DUAL STACK CONVECTION OVEN
7. STAINLESS STEEL COUNTERTOP
8. HAND SINK WITH SOAP AND TOWEL DISPENSER
9. HVAC UNIT
10. STAINLESS STEEL EXHAUST HOOD
11. DRY STORAGE AREA
12. ENTRY DOOR
13. LOADING HATCH
14. ELECTRICAL PANEL
15. FIRE SUPPRESSION SYSTEM
16. FILLER FAUCET
17. MIXER 60 QUART
18. STAIR AND PLATFORM
19. RAMP AND PLATFORM
20. MAKE-UP AIR UNIT
21. 3 COMPARTMENT SINK
22. 36" GRIDDLE WITH STAND
23. 50 LB FRYER
24. 6 BURNER RANGE W/ STANDARD OVEN BELOW
25. MOP SINK
26. WATER HEATER

**FLOOR PLAN**

<b>Kitchens To Go</b>		UNLESS OTHERWISE SPECIFIED DIMENSIONS ARE IN INCHES TOLERANCES ARE: FRACTIONS 1/16 .XX"± .08 ANG ± .5° .XXX± .005	
KTG-711		DO NOT SCALE DRAWINGS	
<b>53' COMMERCIAL KITCHEN</b>		DRAWINGS PREPARED IN ACCORDANCE WITH MIL-13100, MIL-STD-100, AND ANSI Y14.5 SIMILAR TO	
SIZE: B	DATE CODE: 711A01-0-01	REV:	
SCALE: 1/4" = 1'-0"	DWG. NO.: 711A01-0-01	DWG. NO.:	
		DWG. NO.:	
		DWG. NO.:	

<b>CARLIN MANUFACTURING, LLC</b>		DRAWN: GSF		DATE: 06-13-05
FLOOR PLAN AND EQUIPMENT LIST		CHECKED:	DESIGN ACTIVITY:	REV:
SIZE: B	DATE CODE: 711A01-0-01	ENGINEER:		
SCALE: 1/4" = 1'-0"	DWG. NO.: 711A01-0-01	DESIGN ACTIVITY:		
		DWG. NO.:		
		DWG. NO.:		