


THE DESIGN AND DETAILS DISCLOSED HEREIN ARE THE EXCLUSIVE PROPERTY OF CARLIN MANUFACTURING LLC. AND SHALL NOT BE COPIED OR REPRODUCED IN WHOLE OR IN PART WITHOUT THE PRIOR WRITTEN CONSENT OF CARLIN MANUFACTURING LLC. © 2006 CARLIN MANUFACTURING LLC.

REVISIONS				
ZONE	REV	DESCRIPTION	DATE	APPROVED

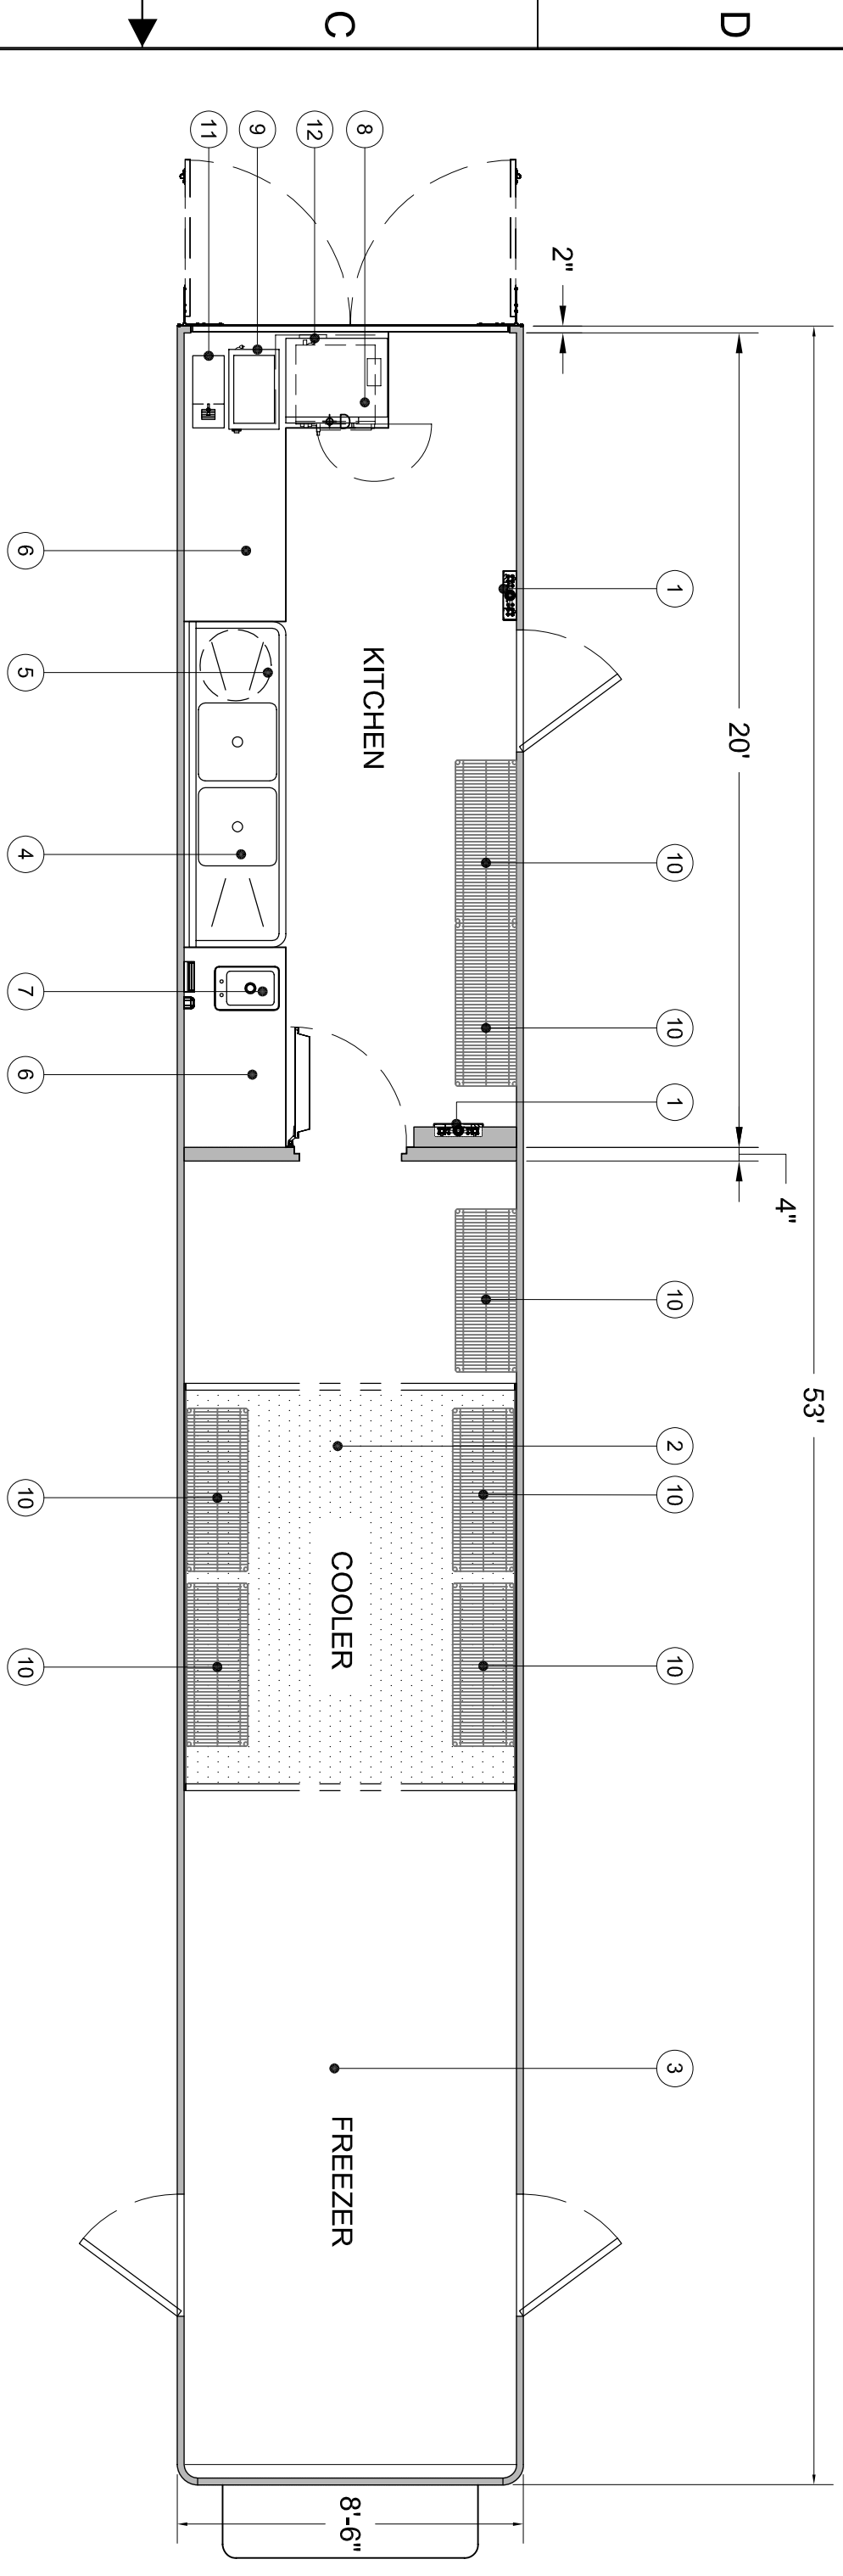

EQUIPMENT LIST:

1. ELECTRICAL PANEL
2. WALK-IN REFRIGERATED AREA
3. WALK-IN FREEZER AREA
4. 2-COMPARTMENT SINK
5. WATER HEATER
6. SS TL COUNTER
7. HAND SINK W/ SOAP & TOWEL DISPENSER
8. COUNTER TOP SOUP WARMER
9. STEAMER
10. METRO SHELVING
11. HOT WATER DISPENSER
12. HALF SIZE CONVECTION OVEN

FINISH SCHEDULE

- KITCHEN:**
- FLOOR - ALUMINUM TREAD PLATE W/ 6" BASE
 - WALLS - FRP
 - CEILING - FRP
- WALK-IN:**
- FLOOR - EXTRUDED ALUMINUM
 - WALLS - FRP
 - CEILING - FRP

Kitchens To Go
UNLESS OTHERWISE SPECIFIED DIMENSIONS ARE IN INCHES TOLERANCES ARE: FRACTIONS DECIMALS
 1/8" ± .005 1/16" ± .005 3/32" ± .005 1/4" ± .005

SIZE	CAGE CODE	DWG. NO.	REV.
B		718A01-0-01	
SCALE		1/4" = 1'-0"	

FLOOR PLAN

CARLIN MANUFACTURING LLC

INT. NO.	KTG-718	DATE	8-9-06
APPROVALS	DESIGNED	CHECKED	ENGR.
FLOOR PLAN AND EQUIPMENT LIST		SIZE	B
		CAGE CODE	718A01-0-01
		SCALE	1/4" = 1'-0"