


THE DESIGN AND DETAILS DISCLOSED HEREIN ARE THE EXCLUSIVE PROPERTY OF CARLIN MANUFACTURING LLC. AND SHALL NOT BE COPIED OR REPRODUCED IN WHOLE OR IN PART WITHOUT THE PRIOR WRITTEN CONSENT OF CARLIN MANUFACTURING LLC. ©2006 CARLIN MANUFACTURING LLC.

REVISIONS				
ZONE	REV	DESCRIPTION	DATE	APPROVED
	1	ADD M.U.A. GAS SCHEMATIC	01-02-07	

FINISH SCHEDULE
 FLOOR: ALTRO STRONGHOLD 30
 CEILING: FIBERGLASS REINFORCED PLASTIC (FRP)
 WALLS: FIBERGLASS REINFORCED PLASTIC (FRP)
 STAINLESS STEEL 18 GA, TYPE 304, FINISH #4, HORIZONTAL GRAIN BEHIND COOKING LINE
 COUNTER: STAINLESS STEEL 16 GA, TYPE 304, FINISH #4, HORIZONTAL GRAIN
 SHELVING: STAINLESS STEEL 16 GA, TYPE 304, FINISH #4, HORIZONTAL GRAIN
 EQUIPMENT: MOUNTED LOOSE, SECURE FOR TRANSPORT.

INSTALLATION:
 ANY GAP LESS THAN 3/8" WIDE TO BE SEALED WITH A SMOOTH SEMI-PERMANENT APPROVED FOOD GRADE CAULK JOINT.
 ANY GAP LARGER THAN 3/8" REQUIRES THE USE OF A CAULK BACK MATERIAL.
 ALL SHARP EDGES TO BE SMOOTHED
 USE 3/16 RIVETS ON ALL STAINLESS RIVETING
 ALL VENTS MUST HAVE SCREENS

- EQUIPMENT LIST:**
- 3-COMPARTMENT SINK
 - HANDSINK W/ SOAP & TOWEL DISPENSER
 - 2-COMPARTMENT SINK
 - REFRIGERATED PREP TABLE
 - 3-DOOR REACH-IN REFRIGERATOR
 - SHELVING W/ LOCKABLE DOORS
 - ENTRY DOOR
 - SST CANOPY HOOD
 - DUAL STACK CONVECTION OVEN
 - FRYER
 - 36" CHAR BROILER
 - 12-BURNER RANGE W/ OVENS BELOW
 - SALAMANDER
 - SSTL BOX HOOD
 - STOCK POT RANGE
 - SPLASH GUARD
 - HVAC UNIT
 - ELECTRICAL PANEL
 - SSTL POT RACK (CEILING MOUNT)
 - SSTL WORK TABLE W/ POWER DROP
 - DATA CONDUIT & TERMINAL
 - FIRE SUPPRESSION SYSTEM
 - WATER HEATER
 - 3-DOOR REACH-IN FREEZER
 - 4-TIER METRO SHELVING

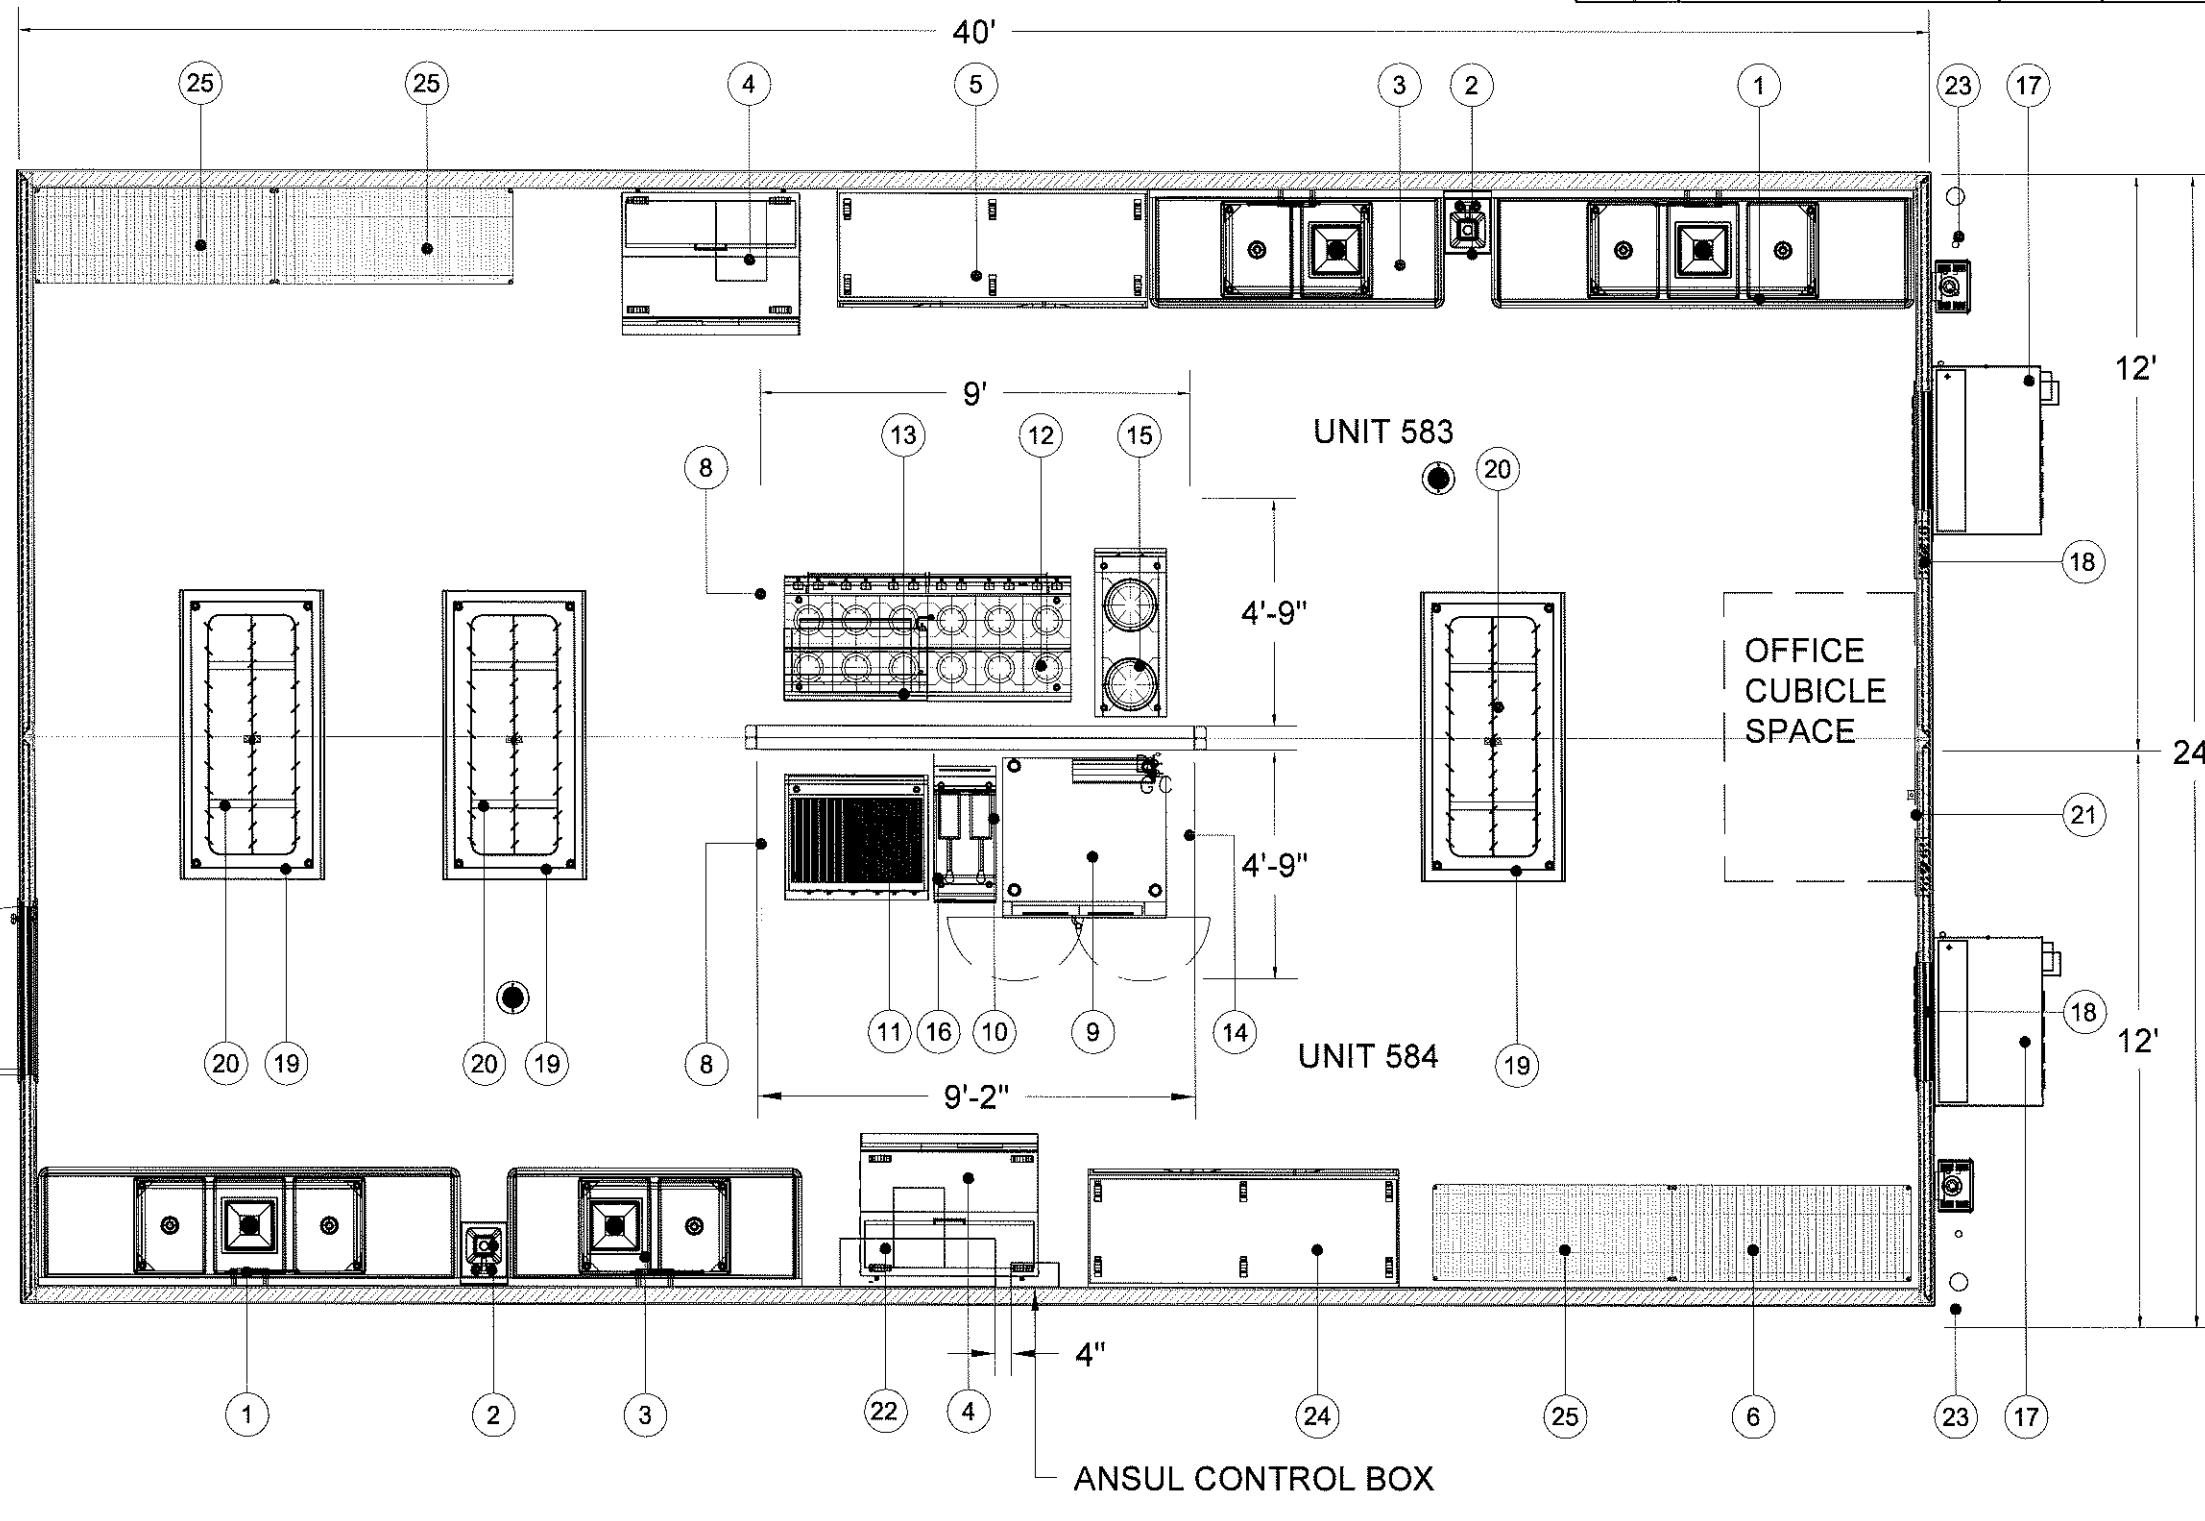

Kitchens To Go
 LANEY COLLEGE COOKING LABORATORY

UNLESS OTHERWISE SPECIFIED DIMENSIONS ARE IN INCHES TOLERANCES ARE:
 FRACTIONS DECIMALS
 FRAC 1/16 .005
 ANG ± .5° .005

DO NOT SCALE DRAWINGS

DRAWINGS PREPARED IN ACCORDANCE WITH MIL-T-3100, MIL-STD-100, AND ANSI Y14.5 SIMILAR TO

UNIT NO. 06-005
 APPROVALS
 DRAWN GSF
 CHECKED
 ENGR
 DESIGN ACTIVITY
 REV.

DATE 07-05-06

CARLIN MANUFACTURING LLC
 FLOOR PLAN AND EQUIPMENT LIST

SIZE B
 CAGE CODE
 DWG NO. 005A01-0-01
 REV.
 SCALE 1/4" = 1' - 0"

FLOOR PLAN

UNIT NO. 06-005
 APPROVALS
 DRAWN GSF
 CHECKED
 ENGR
 DESIGN ACTIVITY
 REV.

DATE 07-05-06

CARLIN MANUFACTURING LLC
 FLOOR PLAN AND EQUIPMENT LIST

SIZE B
 CAGE CODE
 DWG NO. 005A01-0-01
 REV.
 SCALE 1/4" = 1' - 0"