


THE DESIGN AND DETAILS DISCLOSED HEREIN ARE THE EXCLUSIVE PROPERTY OF CARLIN MANUFACTURING LLC. AND SHALL NOT BE COPIED OR REPRODUCED IN WHOLE OR IN PART WITHOUT THE PRIOR WRITTEN CONSENT OF CARLIN MANUFACTURING LLC. © 2005 CARLIN MANUFACTURING LLC.

REVISIONS				
ZONE	REV	DESCRIPTION	DATE	APPROVED

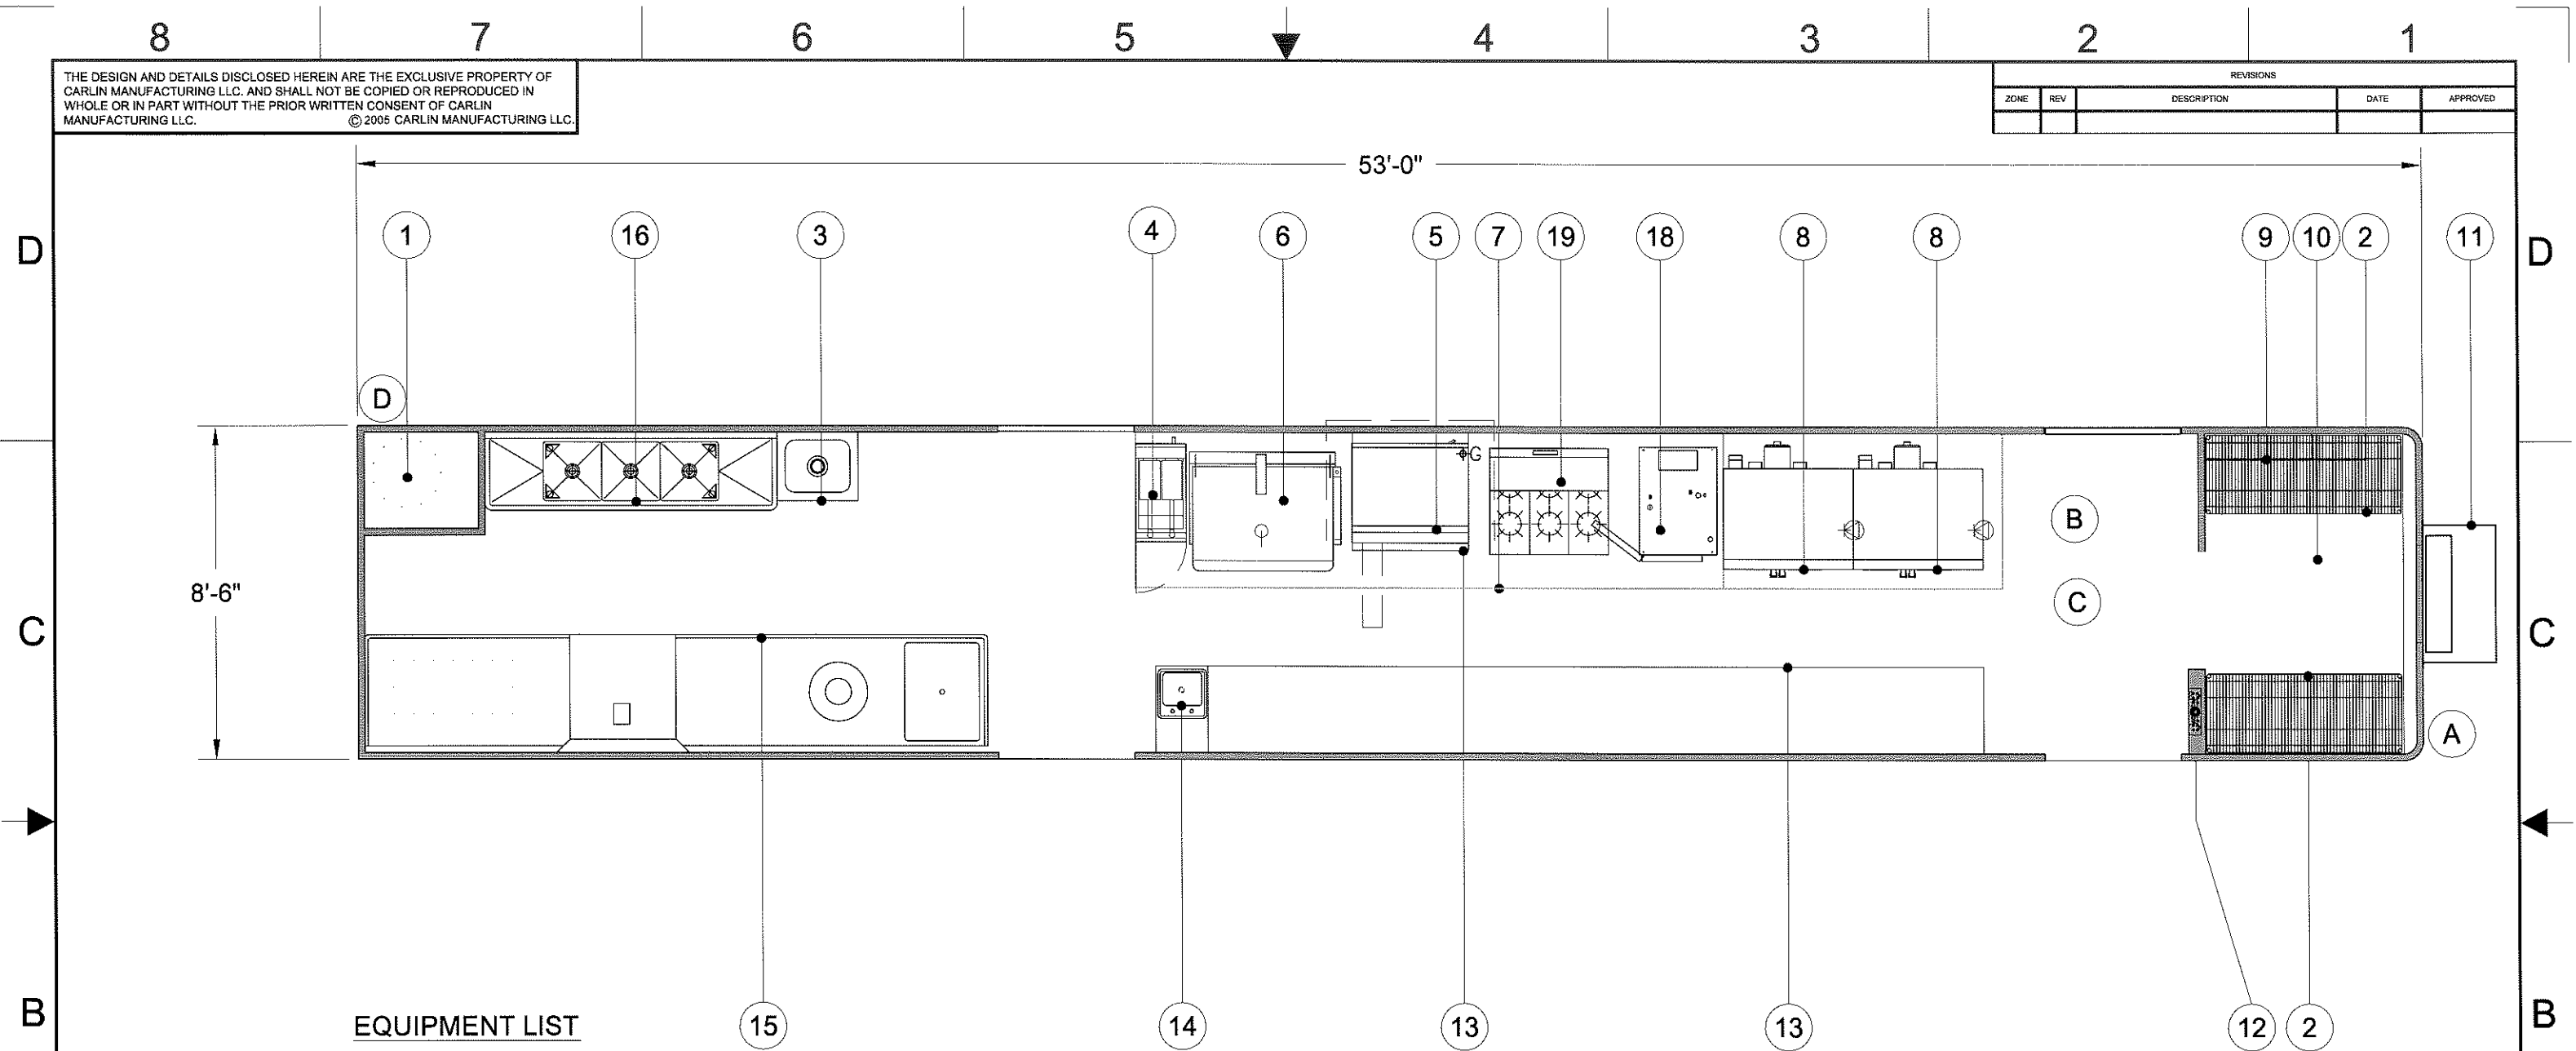

EQUIPMENT LIST

- 1. WATER HEATER
- 2. 4 TIER SHELVING
- 3. MOP SINK
- 4. FRYER
- 5. 36" GRIDDLE
- 6. 30 GAL TILTING SKILLET
- 7. STAINLESS STEEL EXHAUST HOOD
- 8. DUAL STACK CONVECTION OVEN
- 9. FIRE SUPPRESSION SYSTEM
- 10. DRY STORAGE AREA

- 11. HVAC UNIT
- 12. ELECTRICAL PANEL
- 13. STAINLESS STEEL COUNTERTOP
- 14. HAND SINK WITH SOAP AND TOWEL DISPENSER
- 15. STERO U-31-A POT WASHER
- 16. 3 COMPARTMENT SINK
- 17. HEATED HOLDING CABINET
- 18. DUAL STACK STEAMER
- 19. 6-BURNER RANGE

- A. ELECTRICAL CONNECTION (200 AMPS, 120/208V, 3PH)
- B. GAS CONNECTION (1 1/2")
- C. GRAY WATER CONNECTION (3" CAST IRON)
- D. FRESH WATER CONNECTION (1" GALV.)

FLOOR PLAN

Kitchens To Go
KTG #712

UNLESS OTHERWISE SPECIFIED DIMENSIONS ARE IN INCHES TOLERANCES ARE:
FRACTIONS DECIMALS
FRAC: 1/16 .006
ANG ± .5° .005
DO NOT SCALE DRAWINGS

DRAWINGS PREPARED IN ACCORDANCE WITH MIL-1-3100, MIL-STD-100, AND ANSI Y14.5

SIZE	CAGE CODE	DWG. NO.	REV.
B		712A01-0-01	
SCALE	1/4" = 1' - 0"	CALC. WT. ACT. WT.	SHEET

UNIT NO.	KTG-712	CARLIN MANUFACTURING, LLC.	
APPROVALS	DATE	FLOOR PLAN AND EQUIPMENT LIST	
DRAWN RR	6-16-06	SIZE	B
CHECKED		DWG. NO.	712A01-0-01
ENGR		SCALE	1/4" = 1' - 0"
DESIGN ACTIVITY		CALC. WT. ACT. WT.	SHEET
REV.			