


THE DESIGN AND DETAILS DISCLOSED HEREIN ARE THE EXCLUSIVE PROPERTY OF CARLIN MANUFACTURING LLC. AND SHALL NOT BE COPIED OR REPRODUCED IN WHOLE OR IN PART WITHOUT THE PRIOR WRITTEN CONSENT OF CARLIN MANUFACTURING LLC. ©2006 CARLIN MANUFACTURING LLC.

REVISIONS				
ZONE	REV	DESCRIPTION	DATE	APPROVED

**EQUIPMENT LIST:**

1. 4' METRO SHELVING
2. 6' METRO SHELVING
3. 6 BURNER GAS RANGE
4. 30" x 6' SSTL WORK TABLE
5. 36" GAS GRIDDLE
6. 48" CHARBROILER
7. HVAC
8. NOT USED
9. GAS FRYER
10. 24" x 5' SSTL WORK TABLE
11. HAND SINK W/ SOAP & TOWEL DISPENSER
12. ENTRY DOOR
13. DUAL STACK CONVECTION OVEN
14. GAS COMBI OVEN
15. 40 GAL. TILTING SKILLET
16. TRENCH DRAIN
17. 40 GAL. STEAM KETTLE
18. POT SCRUBBER SINK
19. MOP SINK
20. WATER HEATER
21. 8'x20' WALK IN COOLER
22. 8'x20' WALK IN FREEZER
23. PLATFORM & STAIRS
24. ELECTRICAL PANEL
25. GAS STEAM COOKER
26. POT RACK (CEILING MOUNT)
27. SSTL CANOPY HOOD
28. NOT USED
29. 4-COMP. HOT FOOD TABLE
30. 2-DOOR REACH-IN REFRIGERATOR

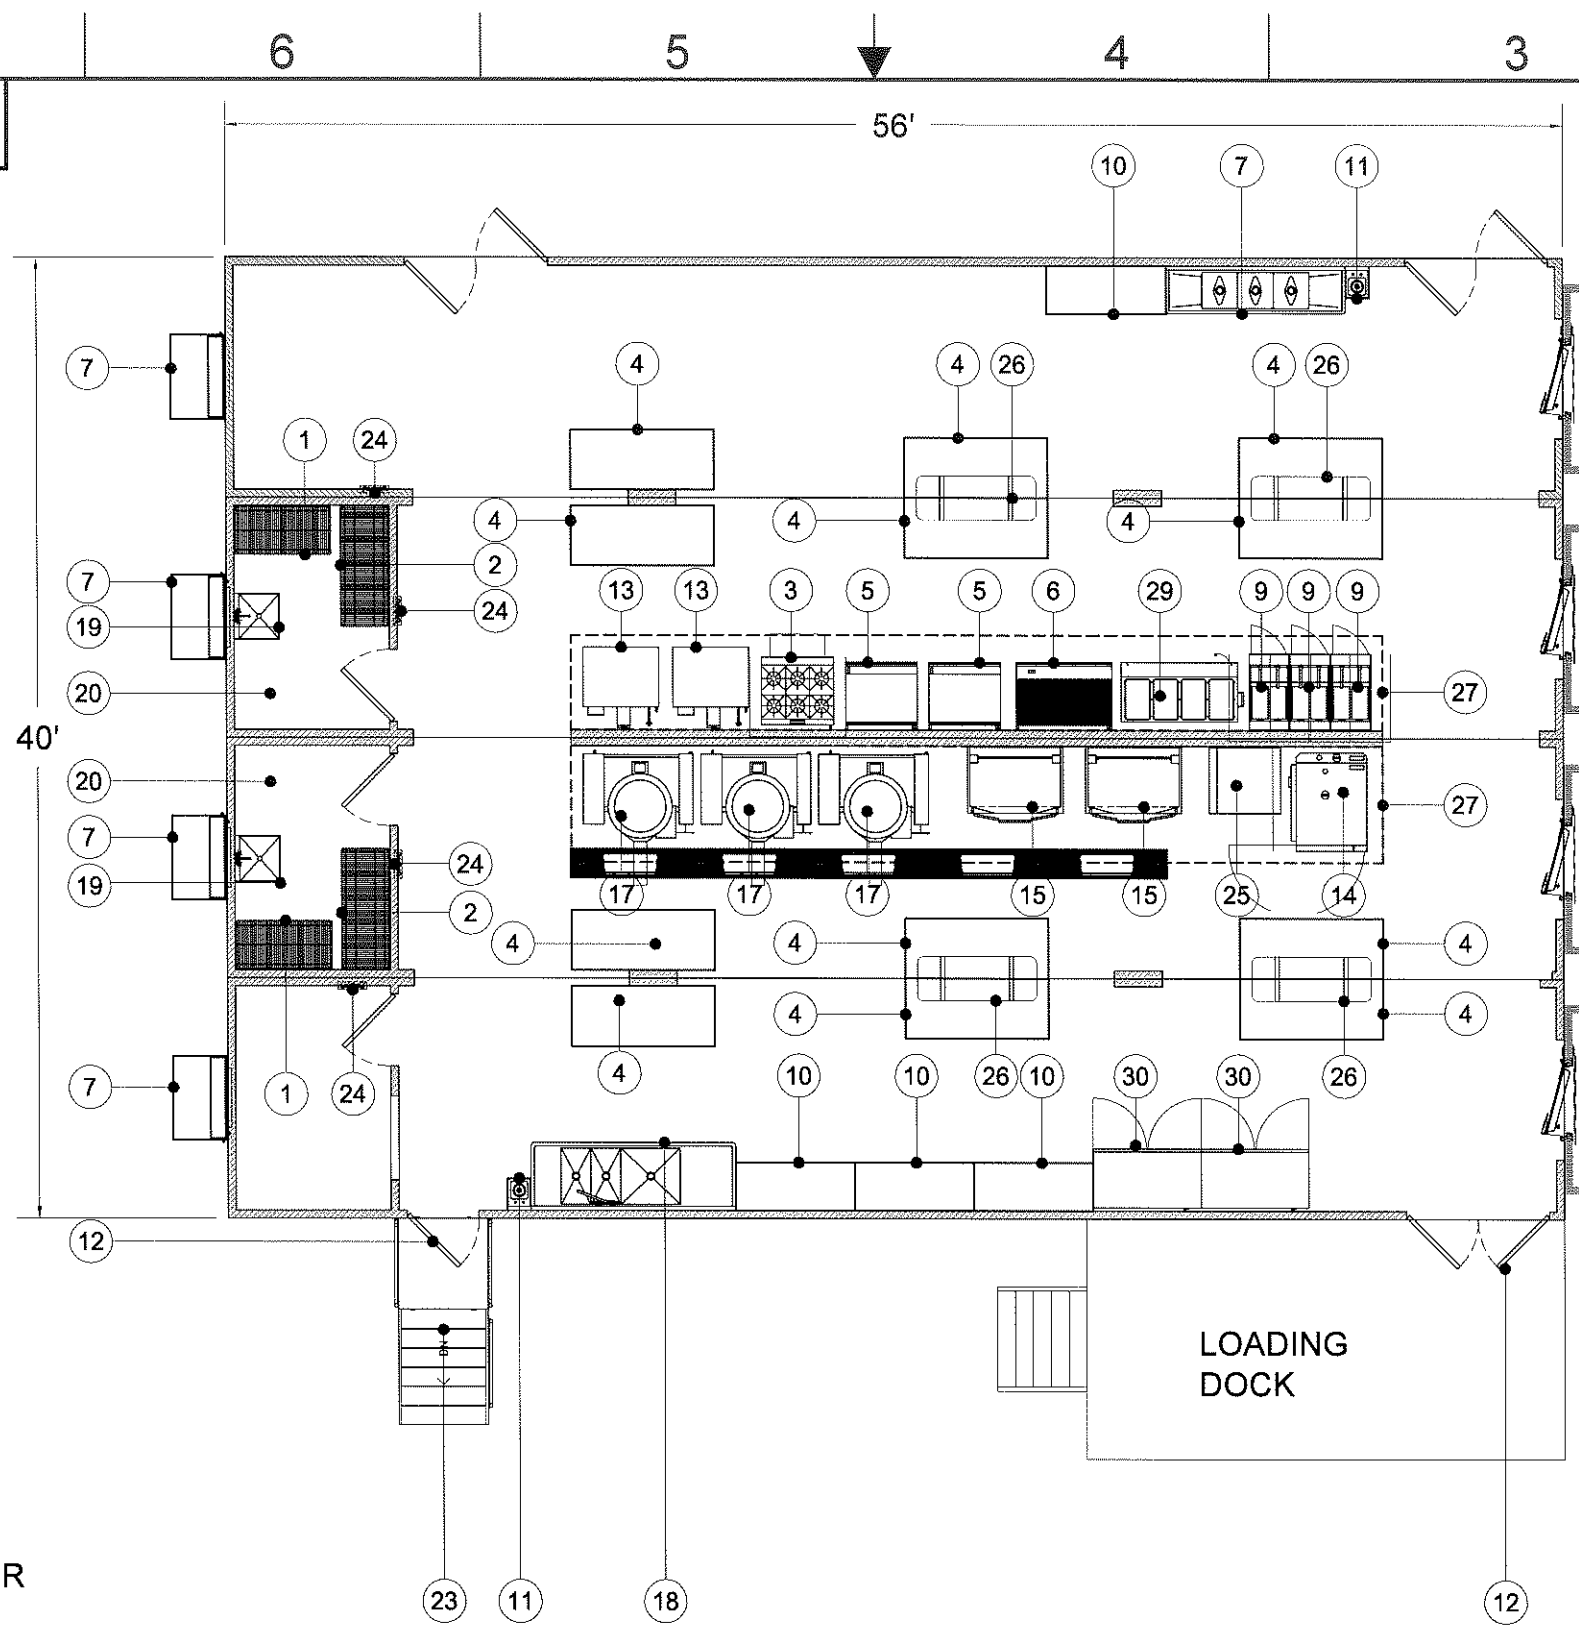

**PRELIMINARY  
NOT FOR  
CONSTRUCTION**

**FLOOR PLAN**

**Kitchens To Go**

PHILLIPS ACADEMY  
SCHEME A.2

UNLESS OTHERWISE SPECIFIED  
DIMENSIONS ARE IN INCHES  
TOLERANCES ARE:  
FRACTIONS DECIMALS  
FRAC<sup>s</sup> 1/16 XX<sup>+</sup> ± .06  
ANG ± 5° XXX<sup>+</sup> ± .005

DO NOT SCALE DRAWINGS

DRAWINGS PREPARED IN  
ACCORDANCE WITH MIL-T-3100,  
MIL-STD-100, AND ANSI Y14.5

SIZE: B CAGE CODE: 136A01-0-01 DWG. NO.: 136A01-0-01 REV.: 1

SCALE: 1/8" = 1' - 0"

UNIT NO: 06-136

APPROVALS: GSF DATE: 01-04-07

**CARLIN**  
MANUFACTURING LLC

FLOOR PLAN  
AND EQUIPMENT LIST

SIZE: B CAGE CODE: 136A01-0-01 DWG. NO.: 136A01-0-01 REV.: 1

SCALE: 1/8" = 1' - 0"