


THE DESIGN AND DETAILS DISCLOSED HEREIN ARE THE EXCLUSIVE PROPERTY OF CARLIN MANUFACTURING LLC. AND SHALL NOT BE COPIED OR REPRODUCED IN WHOLE OR IN PART WITHOUT THE PRIOR WRITTEN CONSENT OF CARLIN MANUFACTURING LLC. © 2006 CARLIN MANUFACTURING LLC.

REVISIONS				
ZONE	REV	DESCRIPTION	DATE	APPROVED

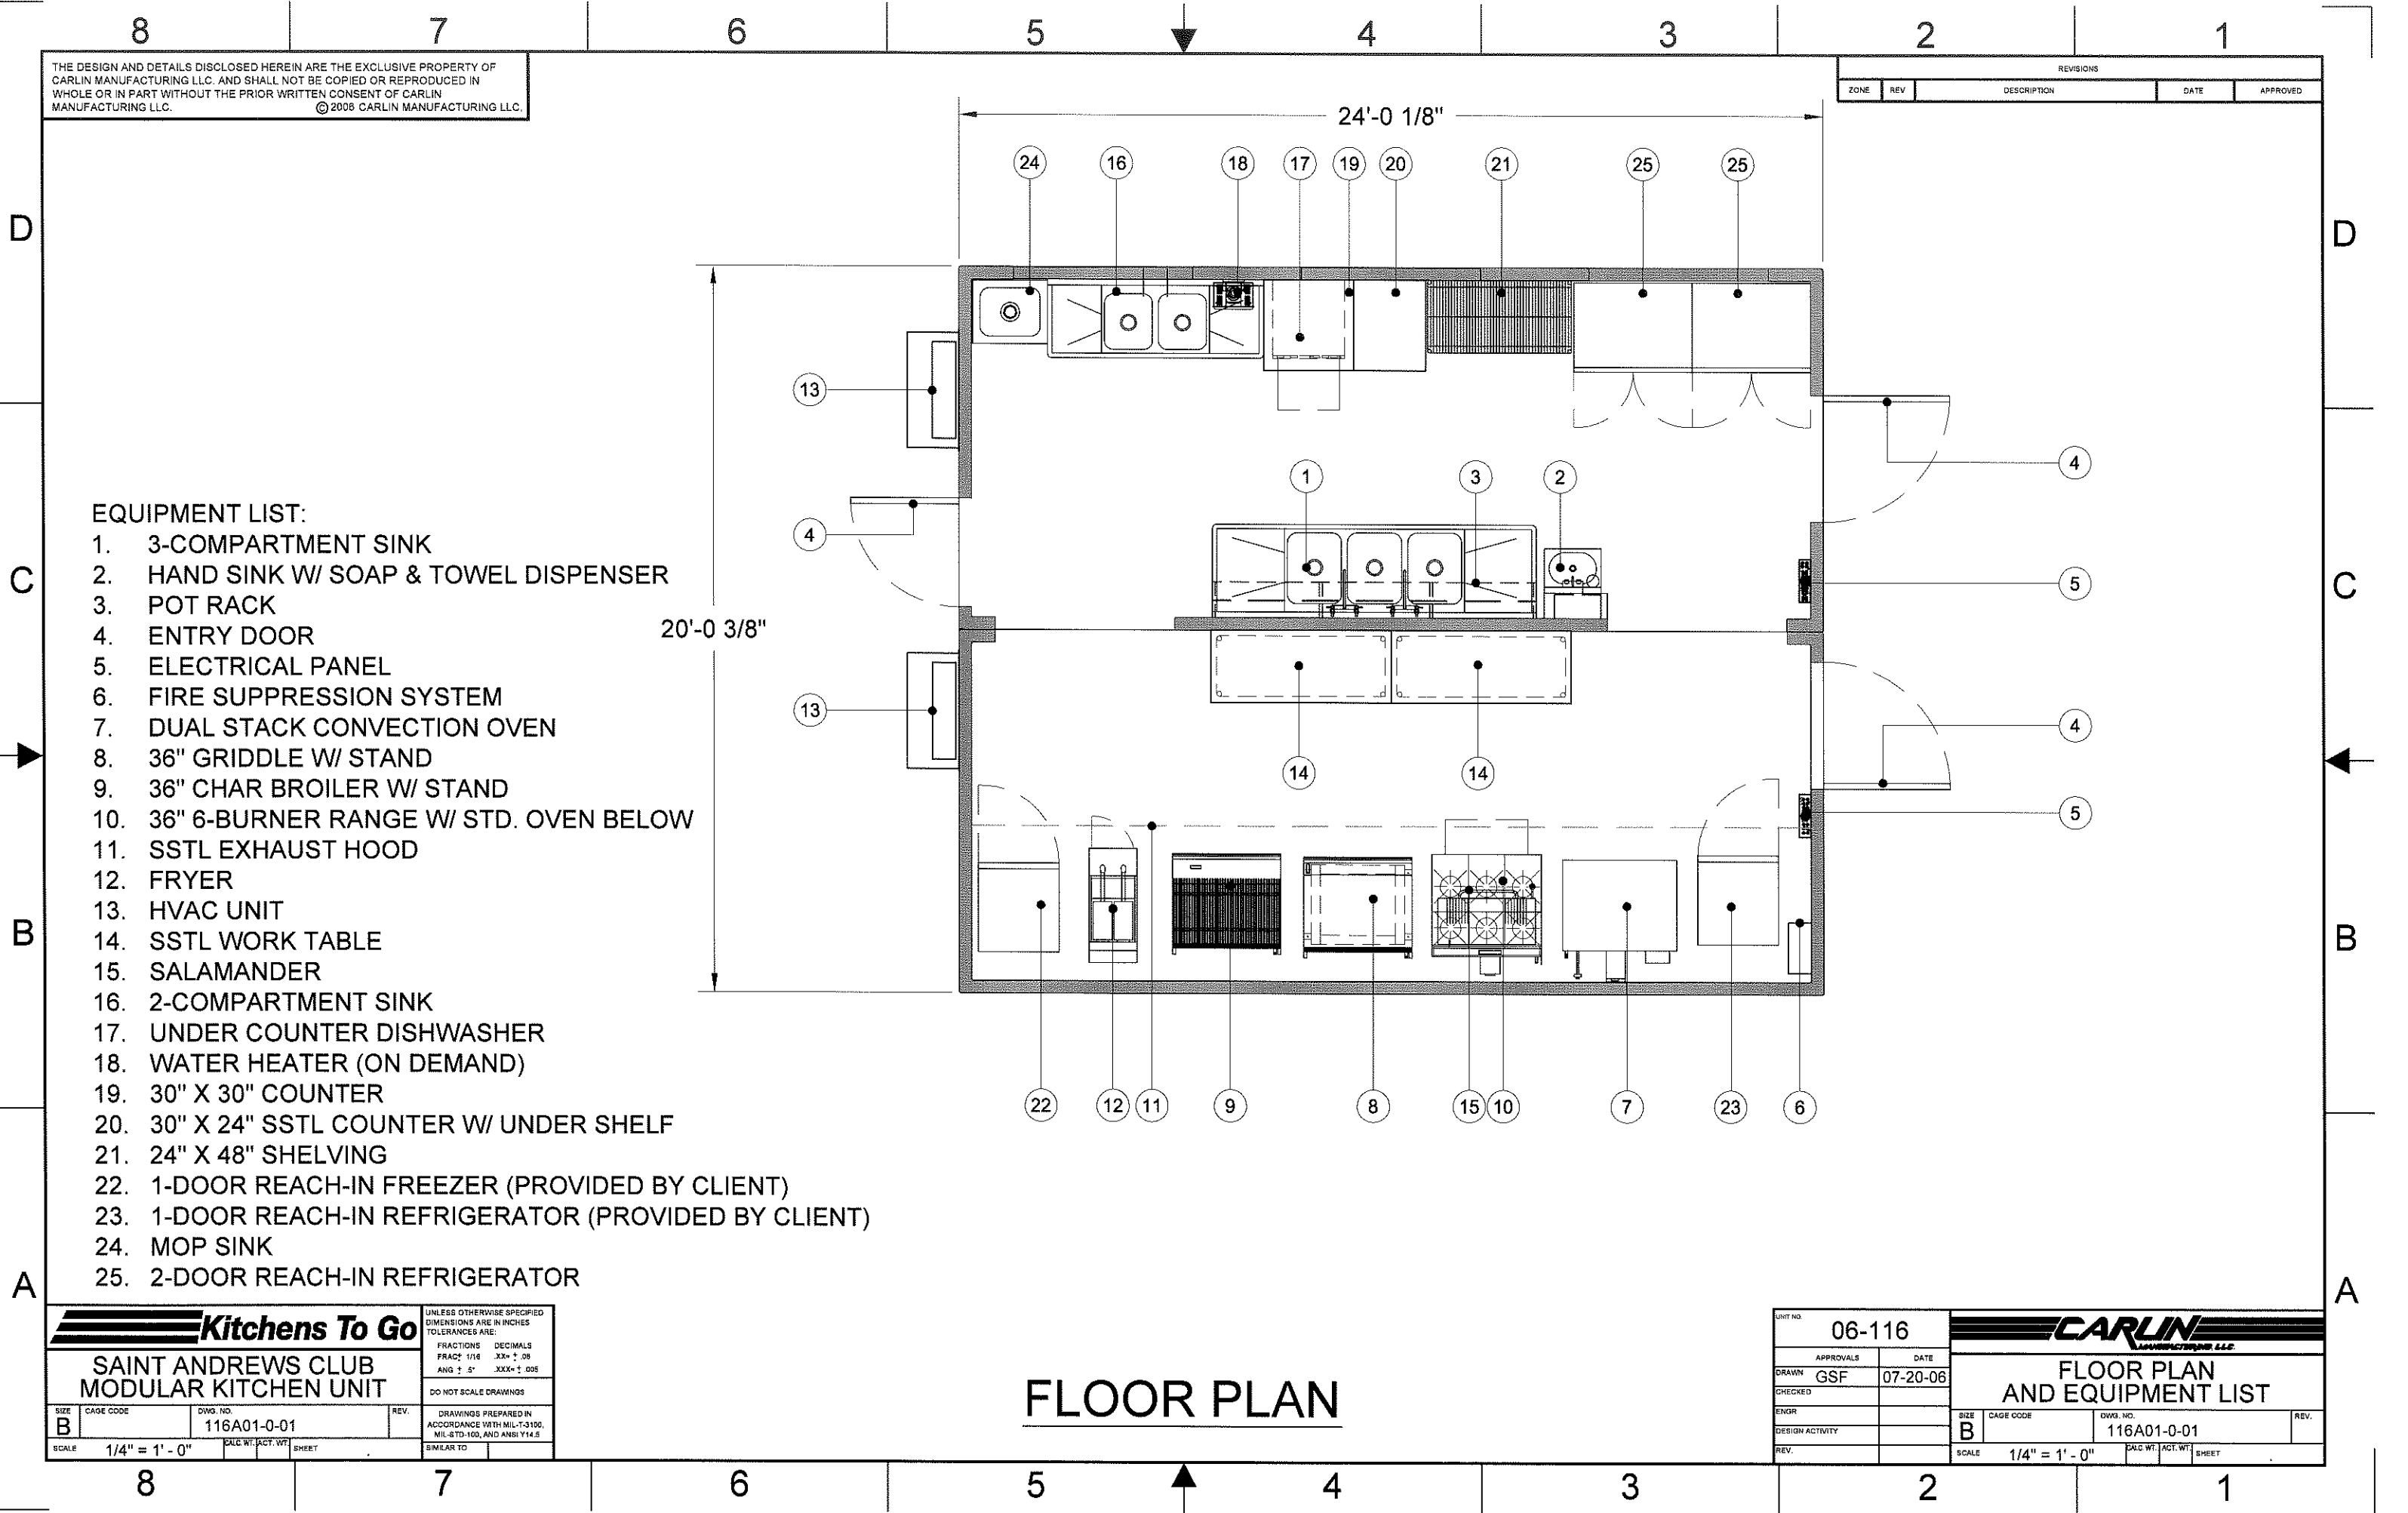

EQUIPMENT LIST:

- 1. 3-COMPARTMENT SINK
- 2. HAND SINK W/ SOAP & TOWEL DISPENSER
- 3. POT RACK
- 4. ENTRY DOOR
- 5. ELECTRICAL PANEL
- 6. FIRE SUPPRESSION SYSTEM
- 7. DUAL STACK CONVECTION OVEN
- 8. 36" GRIDDLE W/ STAND
- 9. 36" CHAR BROILER W/ STAND
- 10. 36" 6-BURNER RANGE W/ STD. OVEN BELOW
- 11. SSTL EXHAUST HOOD
- 12. FRYER
- 13. HVAC UNIT
- 14. SSTL WORK TABLE
- 15. SALAMANDER
- 16. 2-COMPARTMENT SINK
- 17. UNDER COUNTER DISHWASHER
- 18. WATER HEATER (ON DEMAND)
- 19. 30" X 30" COUNTER
- 20. 30" X 24" SSTL COUNTER W/ UNDER SHELF
- 21. 24" X 48" SHELVING
- 22. 1-DOOR REACH-IN FREEZER (PROVIDED BY CLIENT)
- 23. 1-DOOR REACH-IN REFRIGERATOR (PROVIDED BY CLIENT)
- 24. MOP SINK
- 25. 2-DOOR REACH-IN REFRIGERATOR

FLOOR PLAN

Kitchens To Go

**SAINT ANDREWS CLUB
MODULAR KITCHEN UNIT**

UNLESS OTHERWISE SPECIFIED DIMENSIONS ARE IN INCHES TOLERANCES ARE:
 FRACTIONS DECIMALS
 FRAC 1/16 .XX ± .08
 ANG ± 5° .XXX ± .005

DO NOT SCALE DRAWINGS

DRAWINGS PREPARED IN ACCORDANCE WITH MIL-T-3100, MIL-STD-100, AND ANSI Y14.5

SIZE: B CAGE CODE: 116A01-0-01 DWG. NO. 116A01-0-01 REV. SHEET

SCALE: 1/4" = 1' - 0"

UNIT NO. 06-116

CARLIN MANUFACTURING LLC.

FLOOR PLAN AND EQUIPMENT LIST

APPROVALS: GSF DATE: 07-20-06

SIZE: B CAGE CODE: 116A01-0-01 DWG. NO. 116A01-0-01 REV. SHEET

SCALE: 1/4" = 1' - 0"