


ZONE	REV	REVISIONS	DATE	APPROVED
-	-	-		

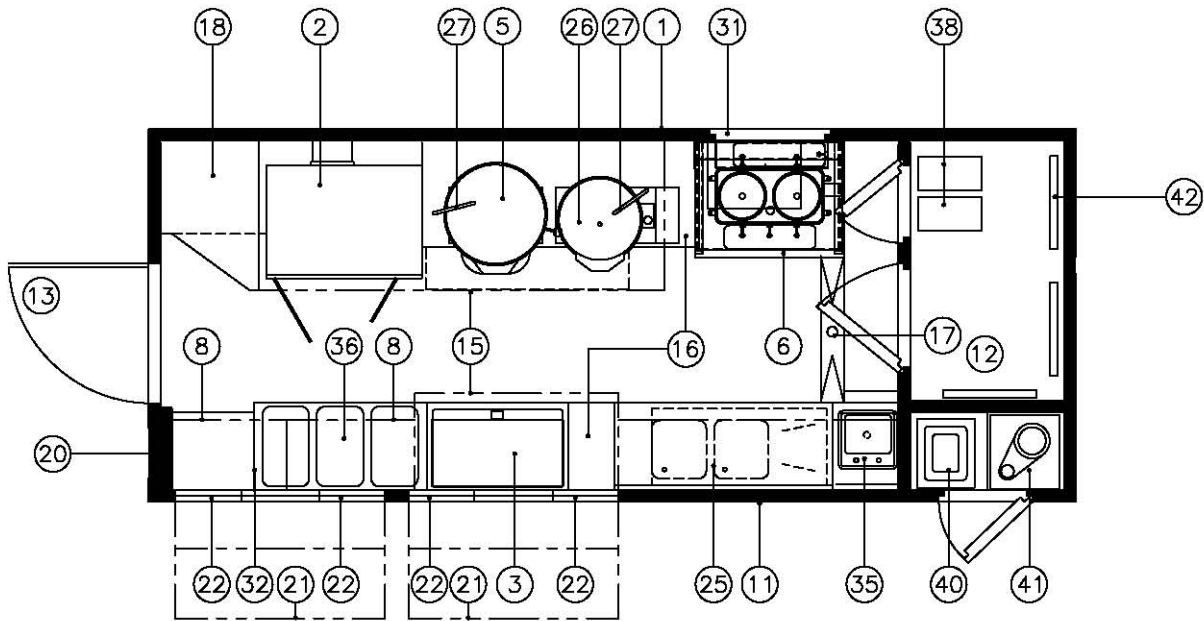

**FLOOR PLAN**

Please note: This drawing shows a typical configuration of equipment and does not necessarily show the equipment currently installed in the unit. Verify the specific equipment currently in the unit with a KTG representative.

**EQUIPMENT LIST**

- |   |   |
|---|---|
| <ul style="list-style-type: none"> <li>1. LOADING DOOR</li> <li>2. DUAL STACK CONVECTION OVENS</li> <li>3. 36" COUNTERTOP GRIDDLE</li> <li>4. 2 DOOR U/C REFRIGERATOR</li> <li>5. 15 GALLON (56.8 LITRE) TILTING SKILLET</li> <li>6. COMPOSITE CUTTING SURFACE HINGED AT WALL FOR ACCESS TO URN BELOW</li> <li>7. POTABLE WATER TANK - 100 GALLONS</li> <li>8. STAINLESS STEEL OVERHEAD STORAGE CABINET</li> <li>9. TWIN 3 GALLON COFFEE URN WITH EXTERIOR SERVING STATION</li> <li>10. NOT USED</li> <li>11. SERVICE DOOR - ACCESS TO WATER PUMP, WATER HEATER &amp; REFRIGERATOR COMPRESSORS</li> <li>12. REACH-IN REFRIGERATOR</li> <li>13. ENTRY DOOR</li> <li>14. STORAGE</li> <li>15. STAINLESS STEEL EXHAUST HOODS</li> <li>16. STAINLESS STEEL COUNTERTOP</li> <li>17. FLOOR DRAIN</li> <li>18. HVAC FAN/COIL ASSY</li> <li>19. GENERATOR COMPARTMENT</li> <li>20. CONTROL CENTER WALL</li> <li>21. SERVICE WINDOW SHIELDS</li> <li>22. PASS-THRU SERVICE WINDOWS</li> <li>23. PAN DRYING RACK</li> </ul> | <ul style="list-style-type: none"> <li>24. PAN RACK</li> <li>25. STAINLESS STEEL 2-COMPARTMENT SINK WITH COMPOSITE FOLD DOWN COUNTER TOP</li> <li>26. 20 GALLON (75.7 LITRE) JACKETED STEAM KETTLE</li> <li>27. WATER SPIGOTS</li> <li>28. MAKE UP AIR FAN (QTY. OF 2 EA)</li> <li>29. NOT USED</li> <li>30. STORAGE COMPARTMENT</li> <li>31. EXTERIOR SELF-SERVICE BEVERAGE STATION WITH LOCKING DOOR</li> <li>32. OPEN</li> <li>33. ROLL OUT DRAIN PAN</li> <li>34. STEP WITH GRAY WATER DRAIN VALVE BELOW</li> <li>35. STAINLESS STEEL HAND SINK</li> <li>36. 3-COMPARTMENT HOT FOOD TABLE</li> <li>37. TOOL DRAWERS</li> <li>38. BEVERAGE CONTAINERS (2 EA.)</li> <li>39. EMERGENCY EXIT/LOADING HATCH</li> <li>40. HVAC COMPRESSOR</li> <li>41. HVAC CONDENSER COIL FAN</li> <li>42. COLD PLATES</li> <li>43. LOADING HATCH</li> <li>44. HVAC GRILLE</li> <li>45. MAKE-UP AIR GRILLES</li> <li>46. NOT USED</li> </ul> |
|---|---|

		UNLESS OTHERWISE SPECIFIED DIMENSIONS ARE IN INCHES TOLERANCES		CONTRACT NO.		<b>CARLIN</b> MANUFACTURING, INC.	
		DECIMALS .X = ± .1      FRAC ± 1/16 .XX = ± .03      ANG ± .5° .XXX = ± .005 BREAK ALL SHARP EDGES .08 MIN.		CUSTOMER			
		DRAWINGS PREPARED IN ACCORDANCE WITH DOD-STD-100, ANSI Y14.5		DRAWN DJS		DATE 7/29/02	
		DO NOT SCALE DRAWINGS		CHECKED		SIZE A	
		FINISH		DESIGN		PART NO. 557	
NEXT ASSY		USED ON		PLANNING NO. MWI-		DWG. NO. 5579301A1	
APPLICATION		MATERIAL		SCALE 1/4" = 1'-0"		REV.	
		CALC WT		CK-1E FLOOR PLAN & EQUIPMENT LIST			
THE DESIGN AND DETAILS DISCLOSED HEREIN ARE THE EXCLUSIVE PROPERTY OF CARLIN MANUFACTURING INC. AND SHALL NOT BE COPIED OR REPRODUCED IN WHOLE OR IN PART WITHOUT THE PRIOR WRITTEN CONSENT OF CARLIN MANUFACTURING INC. © 2002 CARLIN MANUFACTURING INC.							