


Please note: This drawing shows a typical configuration of equipment and does not necessarily show the equipment currently installed in the unit. Verify the specific equipment currently in the unit with a KTG representative.

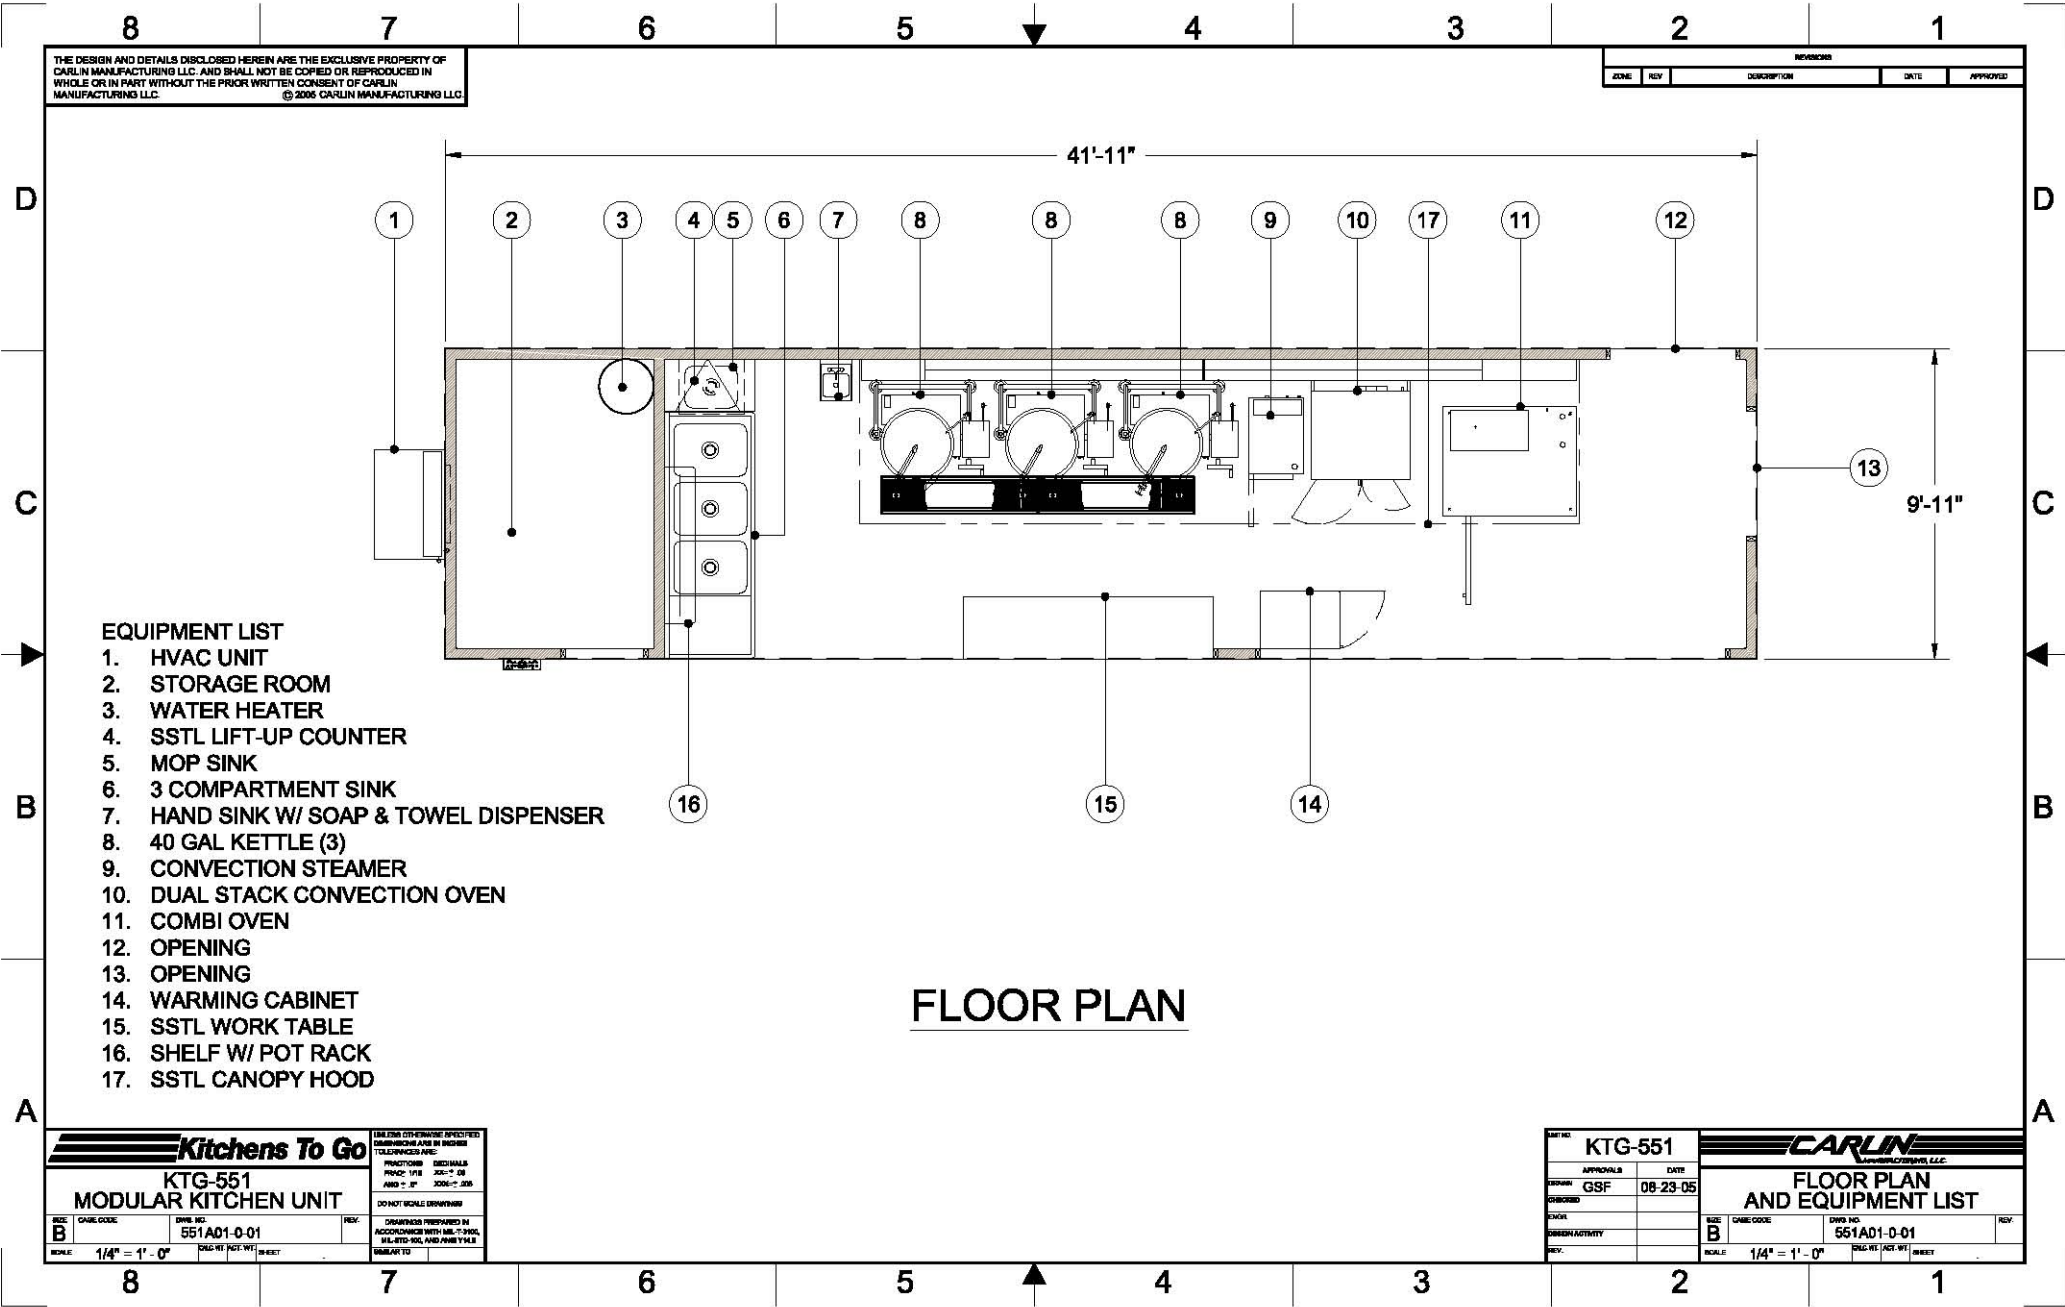

**EQUIPMENT LIST**

- 1. HVAC UNIT
- 2. STORAGE ROOM
- 3. WATER HEATER
- 4. SSSL LIFT-UP COUNTER
- 5. MOP SINK
- 6. 3 COMPARTMENT SINK
- 7. HAND SINK W/ SOAP & TOWEL DISPENSER
- 8. 40 GAL KETTLE (3)
- 9. CONVECTION STEAMER
- 10. DUAL STACK CONVECTION OVEN
- 11. COMBI OVEN
- 12. OPENING
- 13. OPENING
- 14. WARMING CABINET
- 15. SSSL WORK TABLE
- 16. SHELF W/ POT RACK
- 17. SSSL CANOPY HOOD

**FLOOR PLAN**

**Kitchens To Go**  
**KTG-551**  
**MODULAR KITCHEN UNIT**

DATE: 08-23-05  
 DRAWN: GSF  
 CHECKED: [blank]  
 SCALE: 1/4" = 1' - 0"

**CARLIN**  
 FLOOR PLAN AND EQUIPMENT LIST

DATE: 08-23-05  
 DRAWN: GSF  
 CHECKED: [blank]  
 SCALE: 1/4" = 1' - 0"