


Please note: This drawing shows a typical configuration of equipment and does not necessarily show the equipment currently installed in the unit. Verify the specific equipment currently in the unit with a KTG representative.

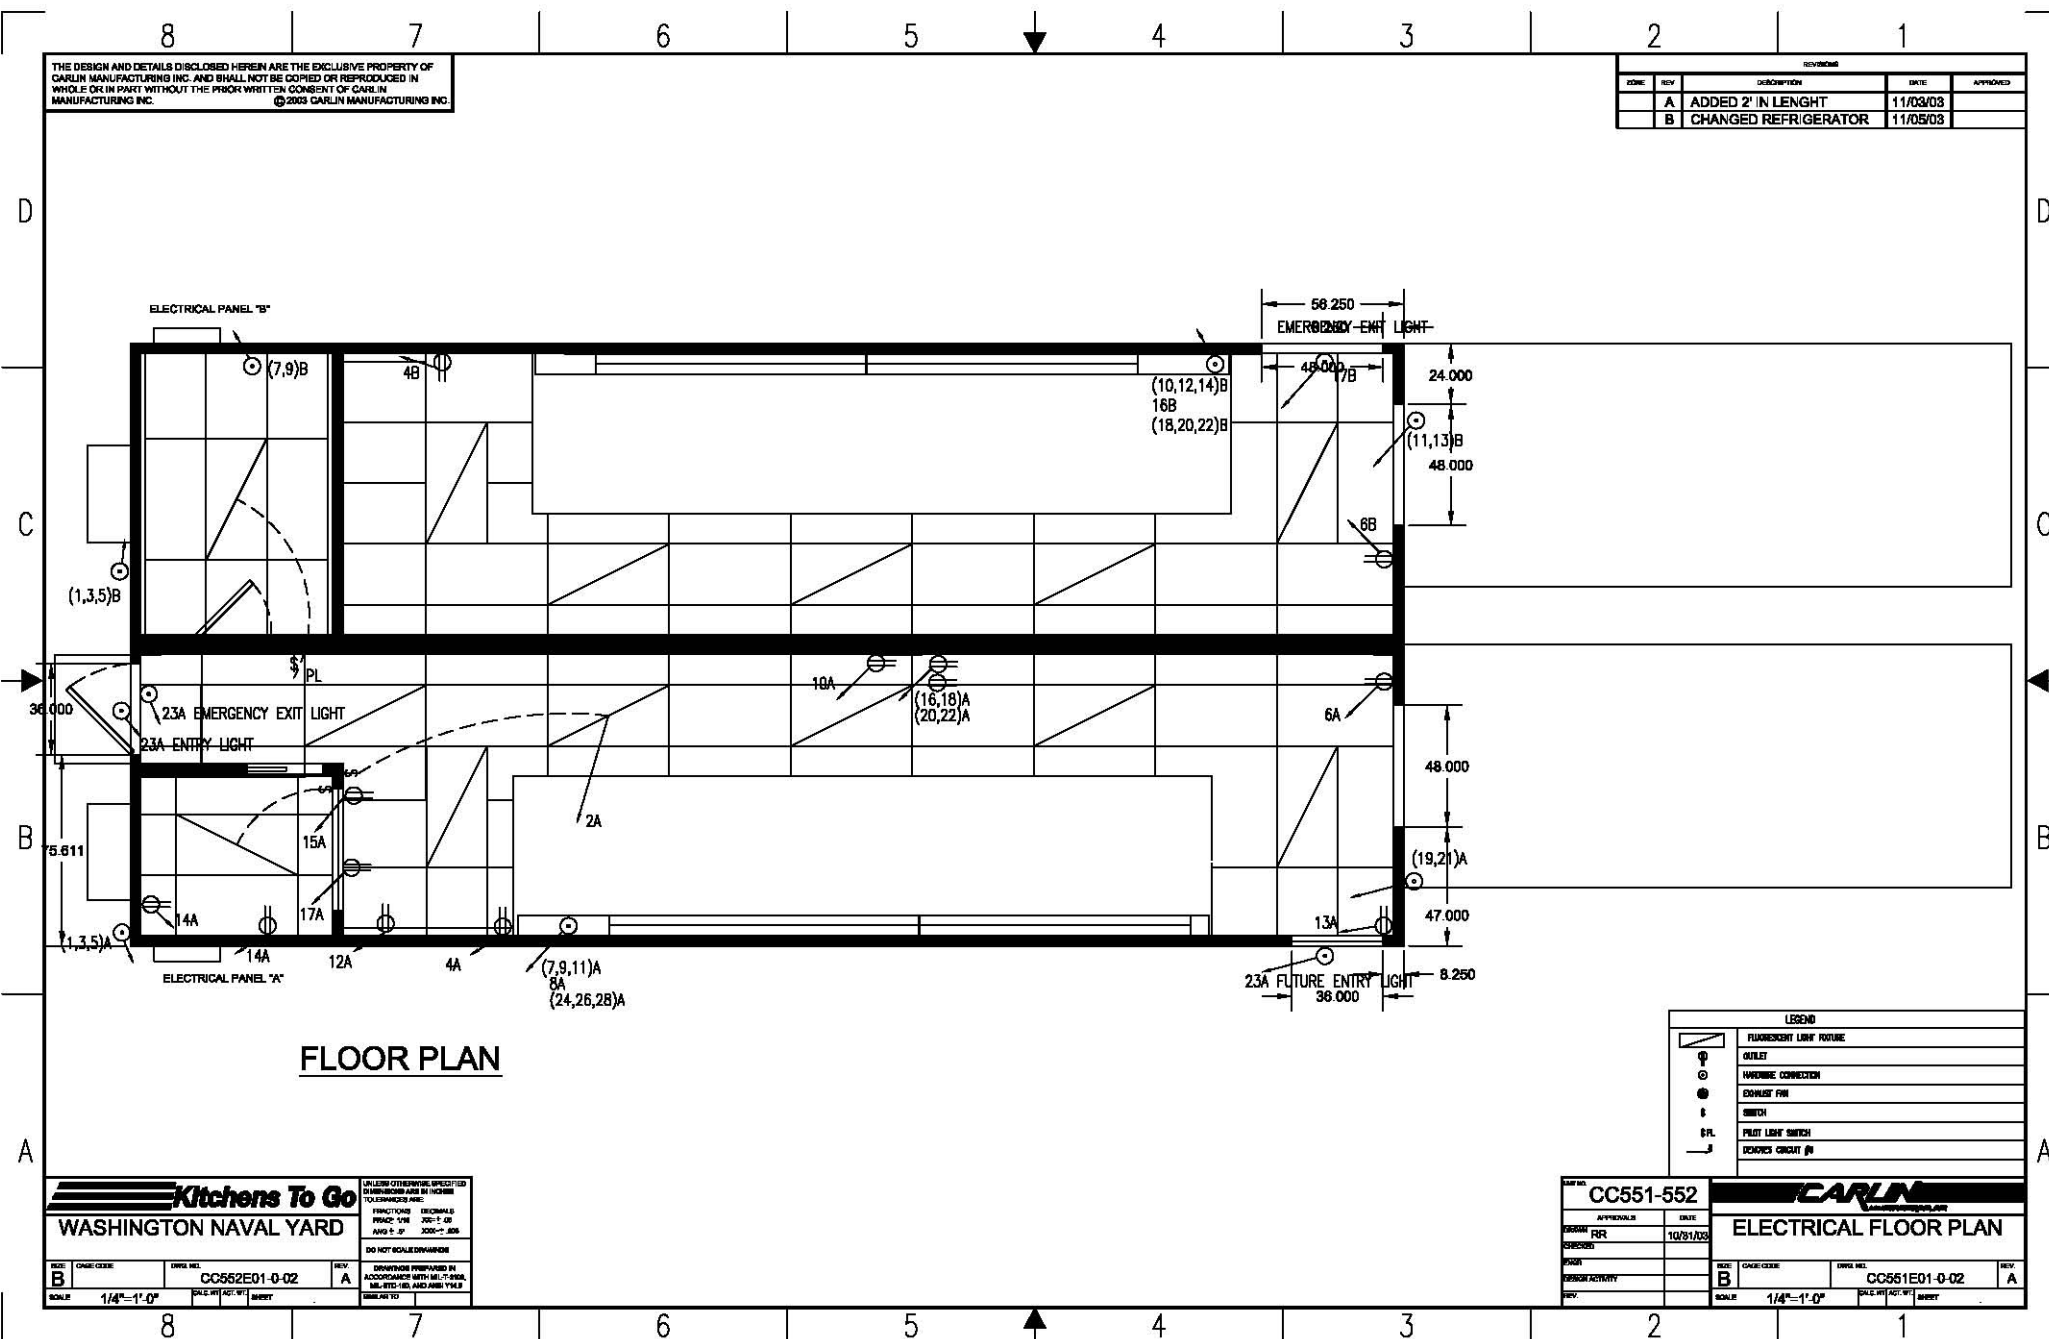

THE DESIGN AND DETAILS DISCLOSED HEREIN ARE THE EXCLUSIVE PROPERTY OF CARLIN MANUFACTURING INC. AND SHALL NOT BE COPIED OR REPRODUCED IN WHOLE OR IN PART WITHOUT THE PRIOR WRITTEN CONSENT OF CARLIN MANUFACTURING INC. ©2003 CARLIN MANUFACTURING INC.

REVISIONS				
CODE	REV	DESCRIPTION	DATE	APPROVED
A		ADDED 2' IN LENGTH	11/03/03	
B		CHANGED REFRIGERATOR	11/05/03	

FLOOR PLAN

Kitchens To Go
WASHINGTON NAVAL YARD

UNLESS OTHERWISE SPECIFIED DIMENSIONS ARE IN INCHES TOLERANCES ARE:
 FINISHES: DIMENSIONAL FINISHES: 1/8" JOINTS: 1/8" ANGLES: 1/4"

DO NOT SCALE DIMENSIONS

DRAWING PREPARED IN ACCORDANCE WITH MIL-STD-883C AND MIL-STD-883B AND MIL-STD-883D

REV: B	DATE: 10/31/03	DESIGN NO.: CC552E01-0-02	REV: A
SCALE: 1/4"=1'-0"	DRAWN BY: [REDACTED]	CHECKED BY: [REDACTED]	DATE: 11/05/03

CC551-552

CARLIN
 MANUFACTURING INC.

ELECTRICAL FLOOR PLAN

REV: B	DATE: 10/31/03	DESIGN NO.: CC551E01-0-02	REV: A
SCALE: 1/4"=1'-0"	DRAWN BY: [REDACTED]	CHECKED BY: [REDACTED]	DATE: 11/05/03