


Please note: This drawing shows a typical configuration of equipment and does not necessarily show the equipment currently installed in the unit. Verify the specific equipment currently in the unit with a KTG representative.

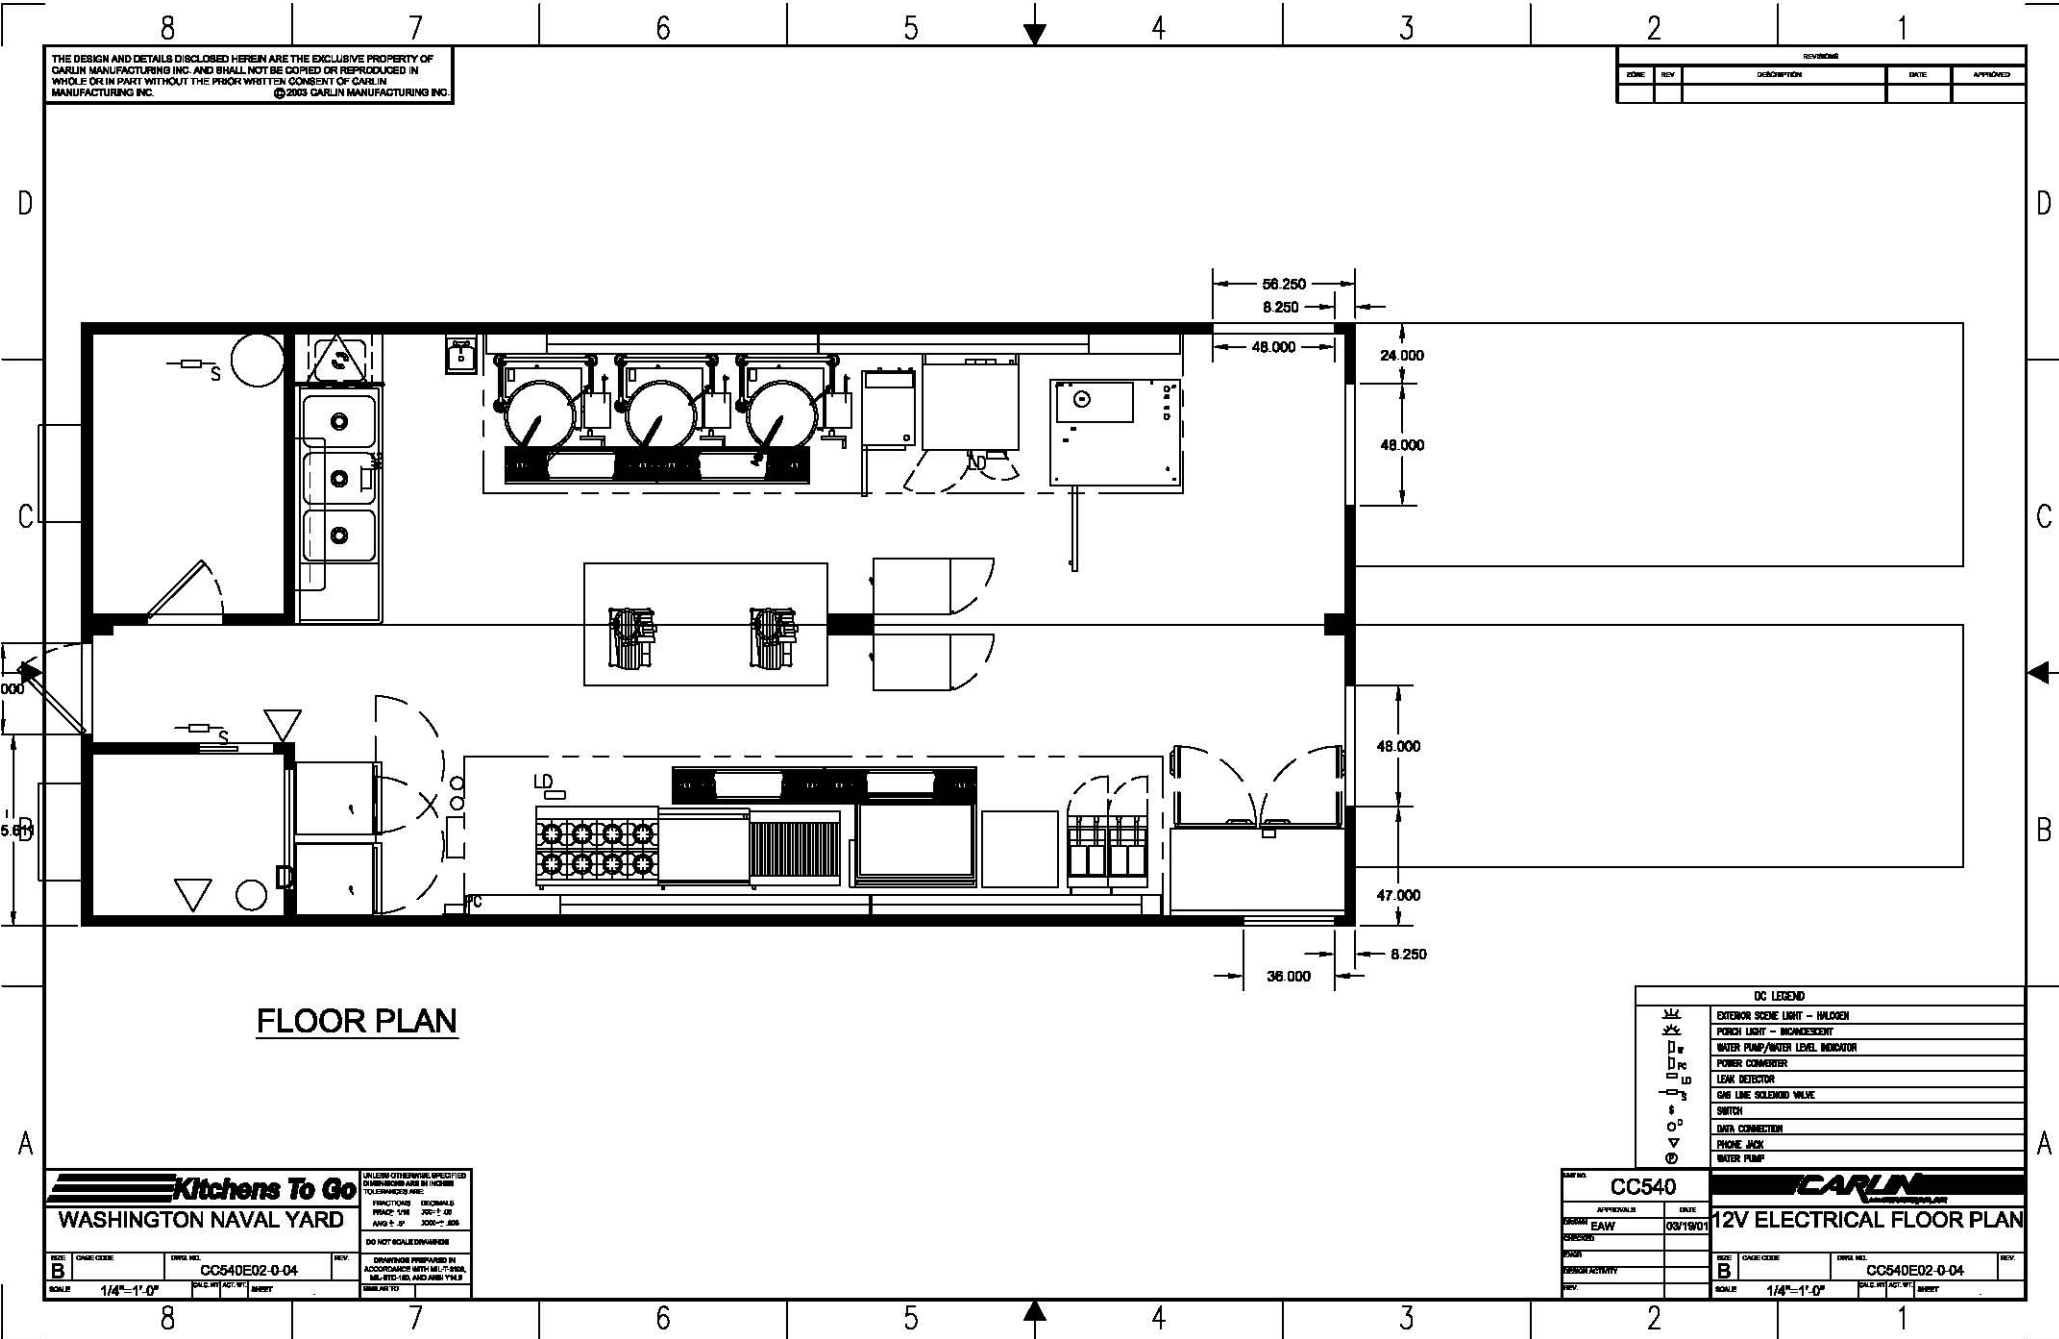

THE DESIGN AND DETAILS DISCLOSED HEREIN ARE THE EXCLUSIVE PROPERTY OF CARLIN MANUFACTURING INC. AND SHALL NOT BE COPIED OR REPRODUCED IN WHOLE OR IN PART WITHOUT THE PRIOR WRITTEN CONSENT OF CARLIN MANUFACTURING INC. ©2003 CARLIN MANUFACTURING INC.

REVISIONS				
CODE	REV	DESCRIPTION	DATE	APPROVED

FLOOR PLAN

DC LEGEND	
	EXTERIOR SCENE LIGHT - HALOGEN
	PORCH LIGHT - INCANDESCENT
	WATER PUMP/WATER LEVEL INDICATOR
	POWER CONVERTER
	LEAK DETECTOR
	GAS LINE SOLENOID VALVE
	SWITCH
	DATA CONNECTION
	PHONE JACK
	WATER PUMP

Kitchens To Go
WASHINGTON NAVAL YARD

UNLESS OTHERWISE SPECIFIED DIMENSIONS ARE IN INCHES TOLERANCES ARE:
FRACTIONS DECIMALS
FRACTIONAL INCHES ± 1/32" DECIMALS ± 0.015"
ANGLES ± 1°

DO NOT SCALE DIMENSIONS

DRAWINGS PREPARED IN ACCORDANCE WITH MIL-STD-883C, MIL-STD-883B AND MIL-STD-883D

REV: B	DATE: 03/19/01	DESIGN NO.: CC540E02-0-04	REV:
SCALE: 1/4"=1'-0"	DRAWN BY: BERRY	CHECKED BY:	DATE: 03/19/01

APPENDIX:	DATE:	CARLIN	
DESIGN: EAW	03/19/01	12V ELECTRICAL FLOOR PLAN	
CHECKED:		REV: B	DATE: 03/19/01
DESIGN ACTIVITY:		DESIGN NO.: CC540E02-0-04	REV:
REV:		SCALE: 1/4"=1'-0"	DRAWN BY: BERRY