


Please note: This drawing shows a typical configuration of equipment and does not necessarily show the equipment currently installed in the unit. Verify the specific equipment currently in the unit with a KTG representative.

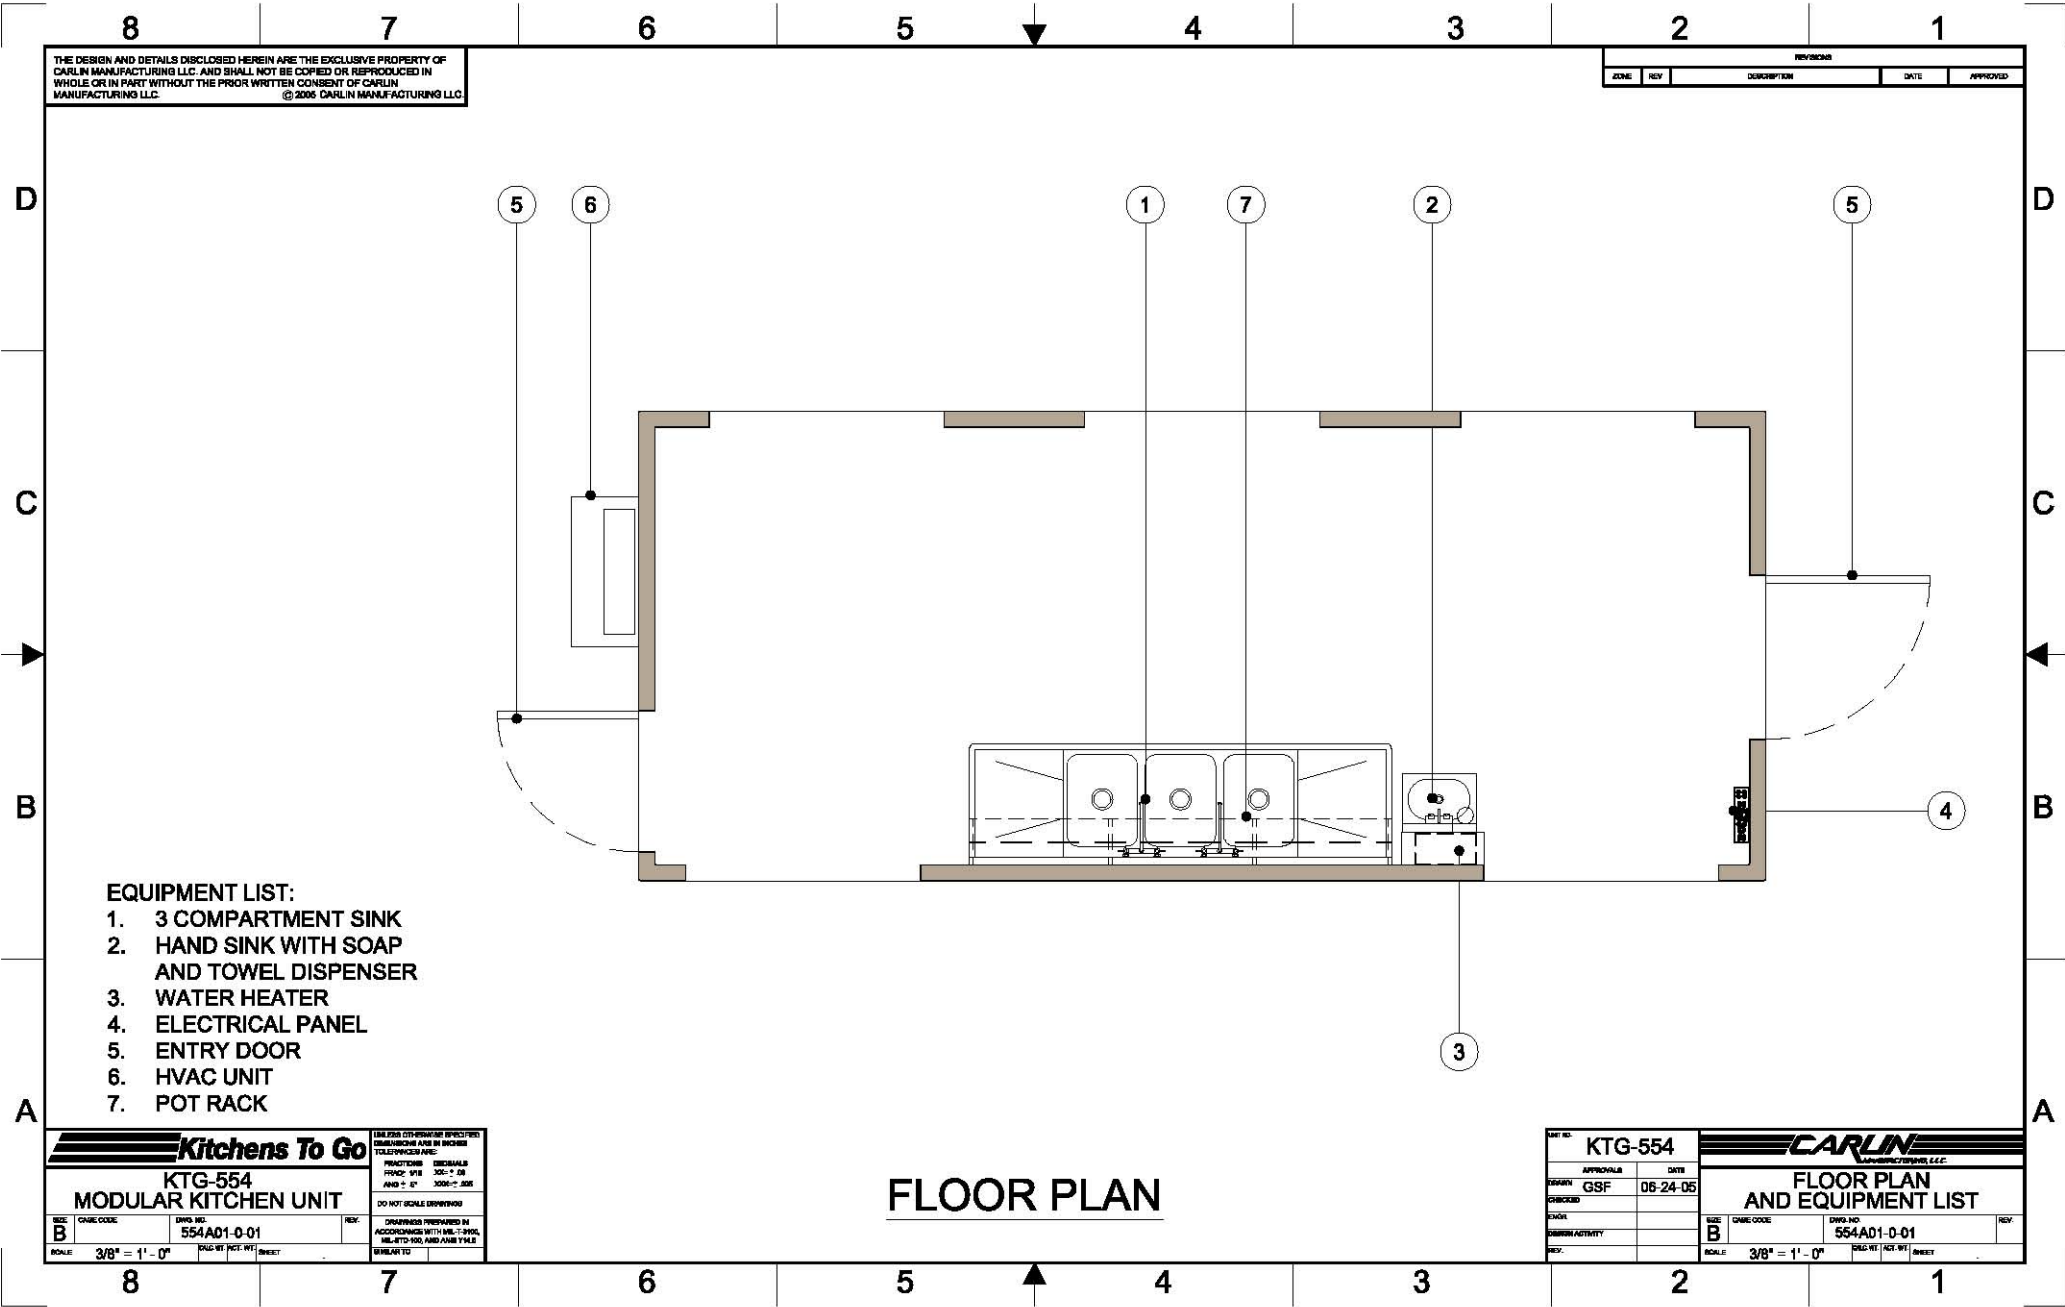

THE DESIGN AND DETAILS DISCLOSED HEREIN ARE THE EXCLUSIVE PROPERTY OF CARLIN MANUFACTURING LLC. AND SHALL NOT BE COPIED OR REPRODUCED IN WHOLE OR IN PART WITHOUT THE PRIOR WRITTEN CONSENT OF CARLIN MANUFACTURING LLC. © 2005 CARLIN MANUFACTURING LLC

REVISIONS				
ZONE	REV	DESCRIPTION	DATE	APPROVED

EQUIPMENT LIST:

1. 3 COMPARTMENT SINK
2. HAND SINK WITH SOAP AND TOWEL DISPENSER
3. WATER HEATER
4. ELECTRICAL PANEL
5. ENTRY DOOR
6. HVAC UNIT
7. POT RACK

Kitchens To Go		<small>ALL DIMENSIONS UNLESS NOTED OTHERWISE ARE IN INCHES TELEPHONE: 800-848-2828 FAX: 313-350-2828 WWW.KITCHENSTOGO.COM</small>	
KTG-554 MODULAR KITCHEN UNIT		<small>DO NOT SCALE DRAWINGS</small>	
<small>SIZE</small> B <small>SCALE</small> 3/8" = 1' - 0"	<small>DATE CODE</small> 554AD1-0-01 <small>DWG. NO.</small> 554AD1-0-01 <small>REV.</small>	<small>DRAWINGS PREPARED BY ADDENDUMS WITH SMC-2002, MEL-2003, AND ASH-2004</small>	

FLOOR PLAN

KTG-554		CARLIN <small>MANUFACTURING, L.L.C.</small>	
<small>APPROVALS</small> <small>DESIGN</small> GSF <small>CHECKED</small> <small>DRAWN</small> <small>ISSUED/ACTIVITY</small> <small>REV.</small>	<small>DATE</small> 06-24-05	FLOOR PLAN AND EQUIPMENT LIST	
<small>SIZE</small> B <small>SCALE</small> 3/8" = 1' - 0"	<small>DATE CODE</small> 554AD1-0-01 <small>DWG. NO.</small> 554AD1-0-01 <small>REV.</small>	<small>DWG. NO.</small> 554AD1-0-01 <small>REV.</small>	