


Please note: This drawing shows a typical configuration of equipment and does not necessarily show the equipment currently installed in the unit. Verify the specific equipment currently in the unit with a KTG representative.

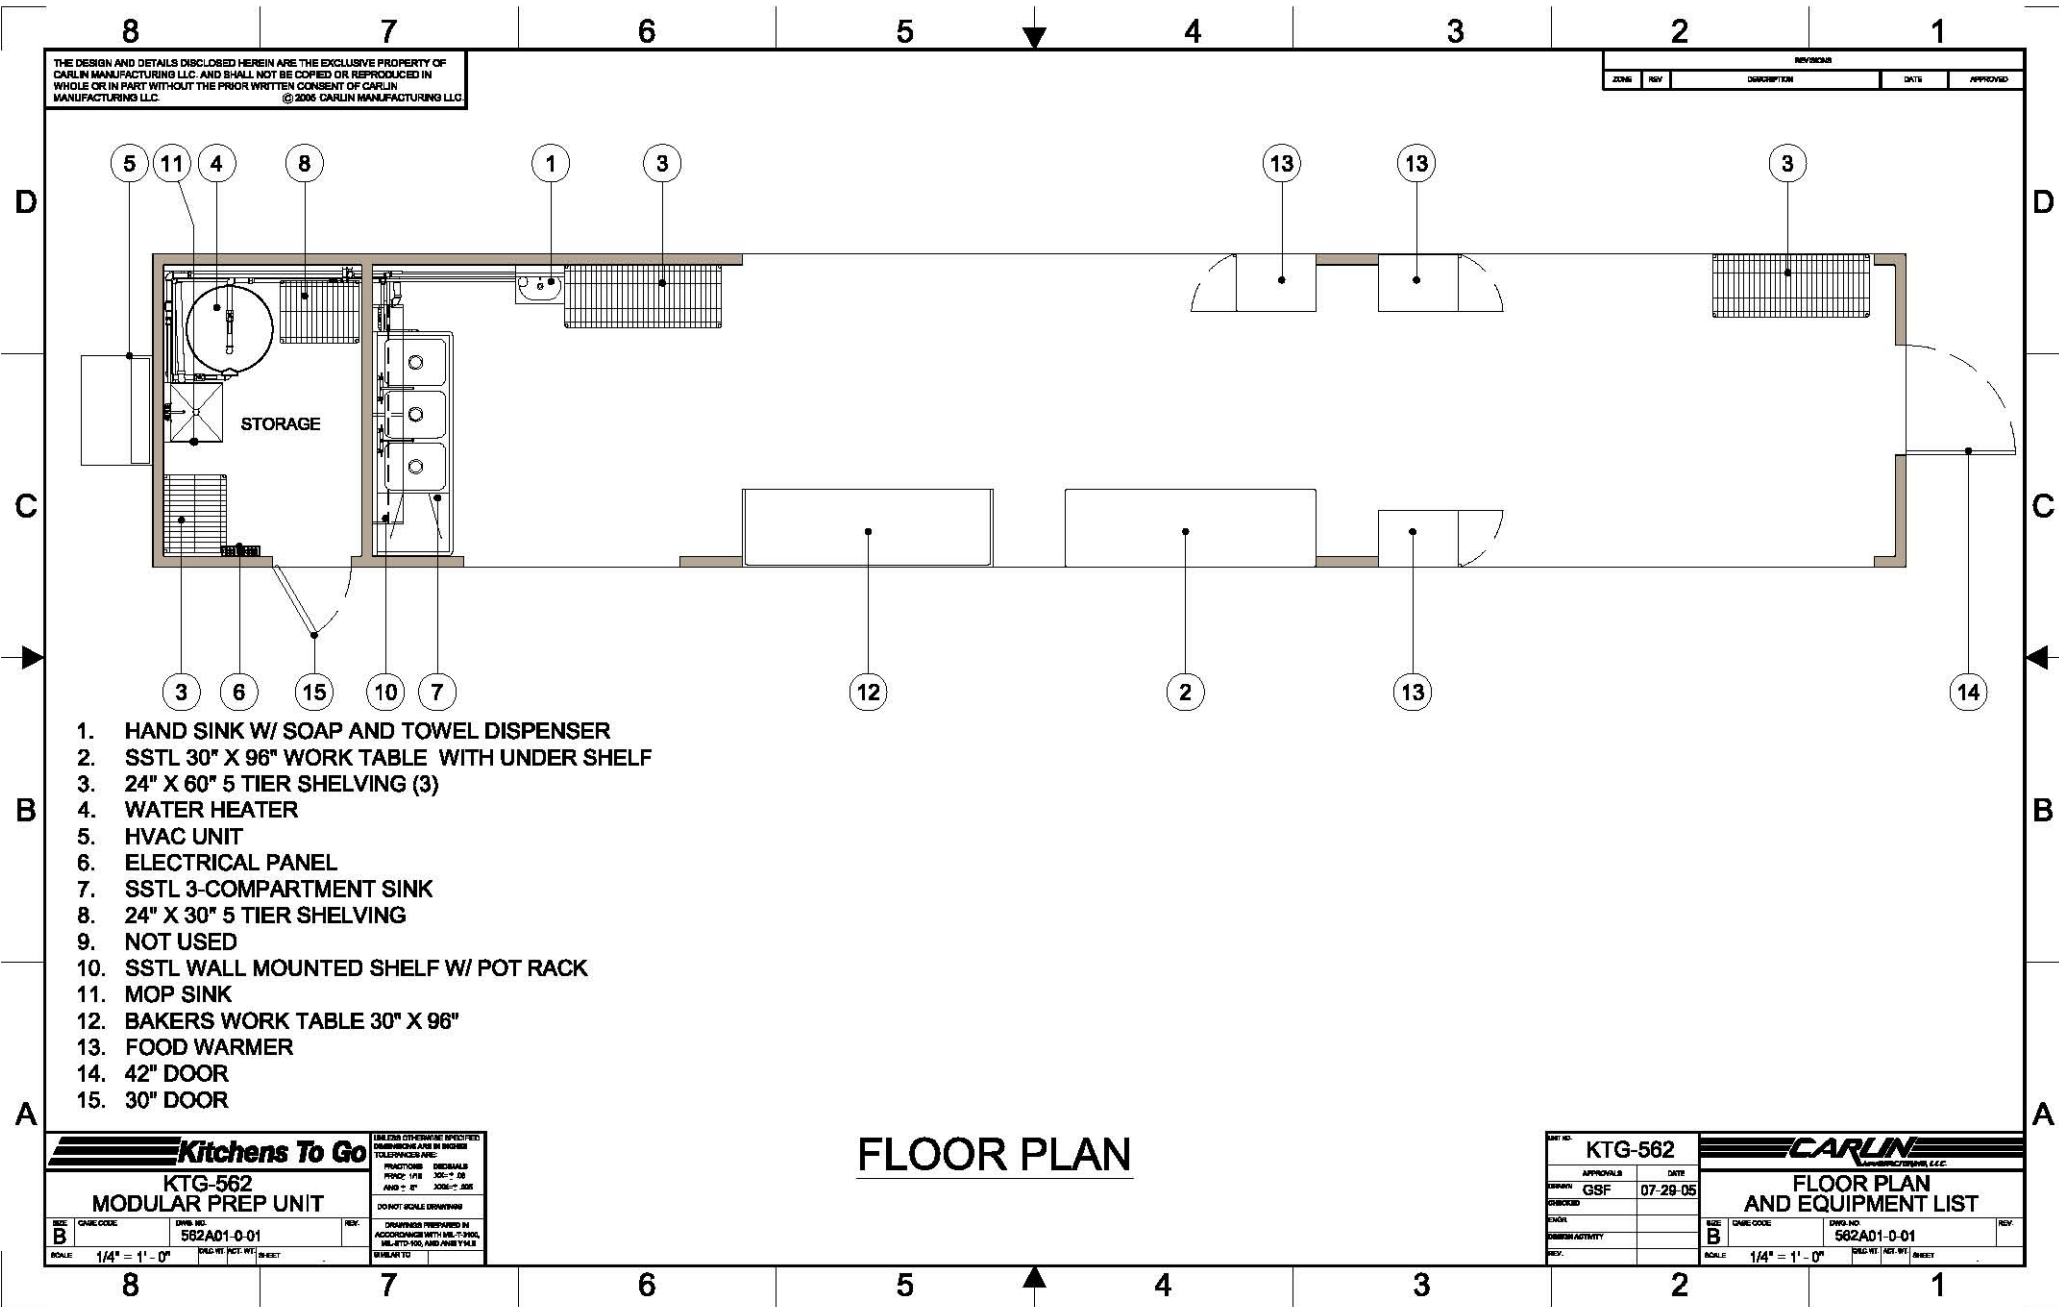

1. HAND SINK W/ SOAP AND TOWEL DISPENSER
2. SSTL 30" X 96" WORK TABLE WITH UNDER SHELF
3. 24" X 60" 5 TIER SHELVING (3)
4. WATER HEATER
5. HVAC UNIT
6. ELECTRICAL PANEL
7. SSTL 3-COMPARTMENT SINK
8. 24" X 30" 5 TIER SHELVING
9. NOT USED
10. SSTL WALL MOUNTED SHELF W/ POT RACK
11. MOP SINK
12. BAKERS WORK TABLE 30" X 96"
13. FOOD WARMER
14. 42" DOOR
15. 30" DOOR

FLOOR PLAN

Kitchens To Go		UNLESS OTHERWISE SPECIFIED DIMENSIONS ARE IN INCHES TOLERANCES ARE:	
KTG-562 MODULAR PREP UNIT		FRACTIONS DECIMALS	FRACTIONS DECIMALS
REV B		1/8" = 3/16"	1/8" = 3/16"
DATE CODE	582AD1-0-01	1/4" = 3/8"	1/4" = 3/8"
SCALE	1/4" = 1' - 0"	1/2" = 1' - 0"	1/2" = 1' - 0"

KTG-562		CARLIN <small>MANUFACTURING, LLC</small>	
APPROVALS	DATE	FLOOR PLAN AND EQUIPMENT LIST	
DESIGN: GSF	07-29-05	REV B	REV
CHECKED:	DATE:	DATE CODE	582AD1-0-01
DESIGN ACTIVITY:	REV:	SCALE	1/4" = 1' - 0"