


Please note: This drawing shows a typical configuration of equipment and does not necessarily show the equipment currently installed in the unit. Verify the specific equipment currently in the unit with a KTG representative.

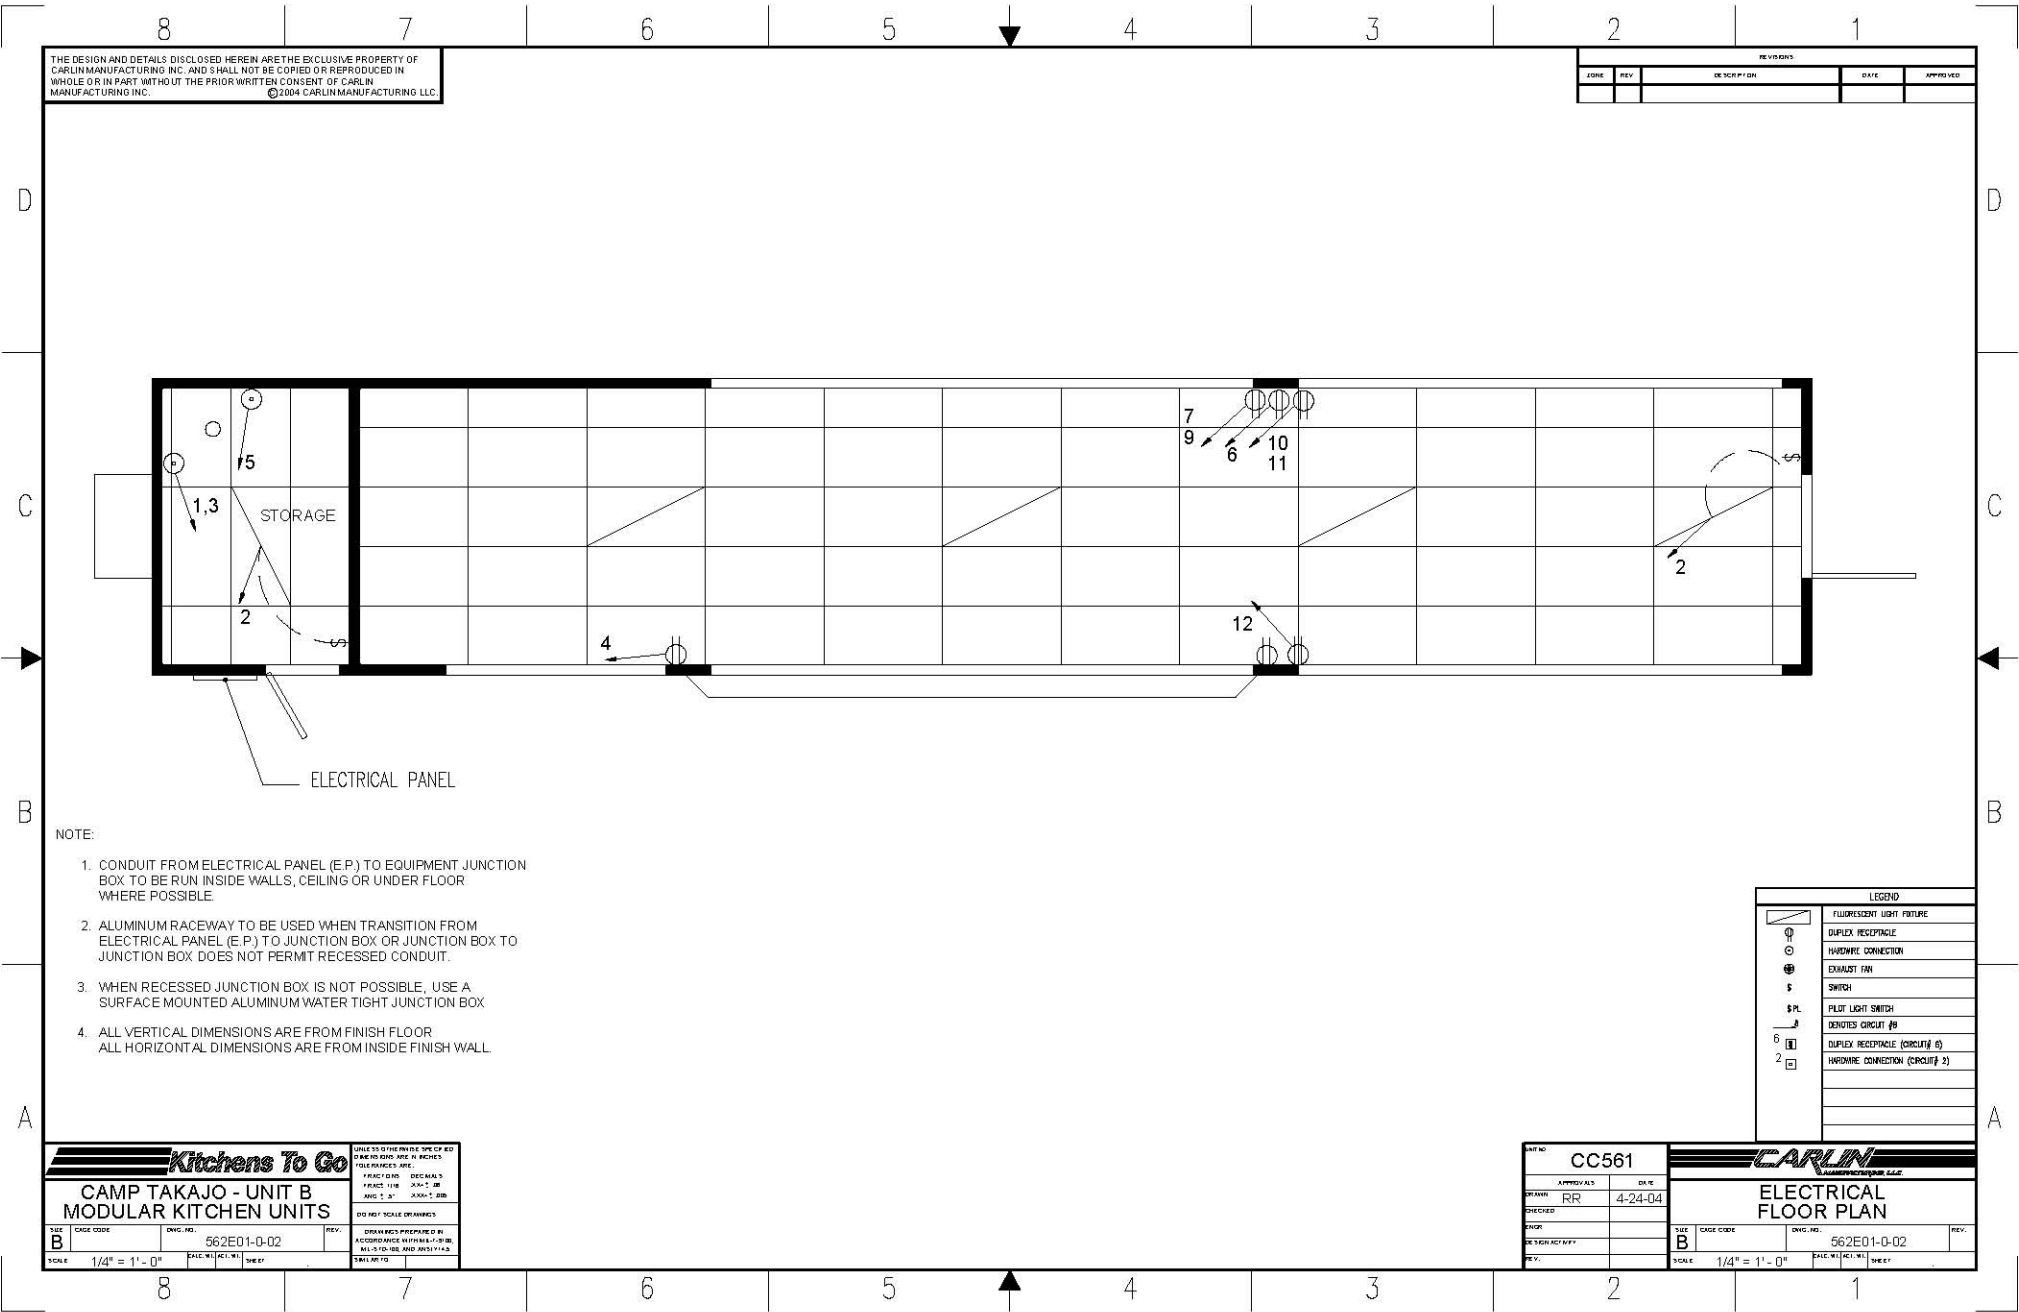

THE DESIGN AND DETAILS DISCLOSED HEREIN ARE THE EXCLUSIVE PROPERTY OF CARLIN MANUFACTURING INC. AND SHALL NOT BE COPIED OR REPRODUCED IN WHOLE OR IN PART WITHOUT THE PRIOR WRITTEN CONSENT OF CARLIN MANUFACTURING INC. ©2004 CARLIN MANUFACTURING LLC.

REVISIONS				
ZONE	REV	DESCRIPTION	DATE	APPROVED

- NOTE:
1. CONDUIT FROM ELECTRICAL PANEL (E.P.) TO EQUIPMENT JUNCTION BOX TO BE RUN INSIDE WALLS, CEILING OR UNDER FLOOR WHERE POSSIBLE.
 2. ALUMINUM RACEWAY TO BE USED WHEN TRANSITION FROM ELECTRICAL PANEL (E.P.) TO JUNCTION BOX OR JUNCTION BOX TO JUNCTION BOX DOES NOT PERMIT RECESSED CONDUIT.
 3. WHEN RECESSED JUNCTION BOX IS NOT POSSIBLE, USE A SURFACE MOUNTED ALUMINUM WATER TIGHT JUNCTION BOX.
 4. ALL VERTICAL DIMENSIONS ARE FROM FINISH FLOOR. ALL HORIZONTAL DIMENSIONS ARE FROM INSIDE FINISH WALL.

LEGEND	
	FLUORESCENT LIGHT FIXTURE
	DUPLEX RECEPTACLE
	HARDWIRE CONNECTION
	EXHAUST FAN
	SWITCH
	PILOT LIGHT SWITCH
	DENOTES CIRCUIT #
	DUPLEX RECEPTACLE (CIRCUIT# 6)
	HARDWIRE CONNECTION (CIRCUIT# 2)

Kitchens To Go		UNLESS OTHERWISE SPECIFIED, DIMENSIONS ARE IN INCHES. TOLERANCES ARE:	
CAMP TAKAJO - UNIT B MODULAR KITCHEN UNITS		FINISH DIM. DECIMALS	FRACTIONS
SIZE: B CAGE CODE: 562E01-0-02 DWG. NO.: 562E01-0-02 REV.:		FINISH DIM. 1/8"	1/16"
SCALE: 1/4" = 1'-0"		FINISH DIM. 1/4"	1/8"
DATE: 4-24-04		FINISH DIM. 3/16"	1/4"
DRAWINGS PREPARED BY: RR		FINISH DIM. 1/2"	3/8"
DESIGNED BY: RR		FINISH DIM. 1"	3/4"
CHECKED BY: RR		FINISH DIM. 2"	1"
DATE: 4-24-04		FINISH DIM. 4"	2"
SCALE: 1/4" = 1'-0"		FINISH DIM. 8"	4"

UNIT NO: CC561		CARLIN MANUFACTURING LLC	
APPROVALS:	DATE:	ELECTRICAL FLOOR PLAN	
DRAWN: RR	4-24-04	SIZE: B	CAGE CODE: 562E01-0-02
CHECKED:		DWG. NO.:	REV.:
DATE:		SCALE: 1/4" = 1'-0"	DATE: 4-24-04
DESIGNED BY:			
DATE:			