


Please note: This drawing shows a typical configuration of equipment and does not necessarily show the equipment currently installed in the unit. Verify the specific equipment currently in the unit with a KTG representative.

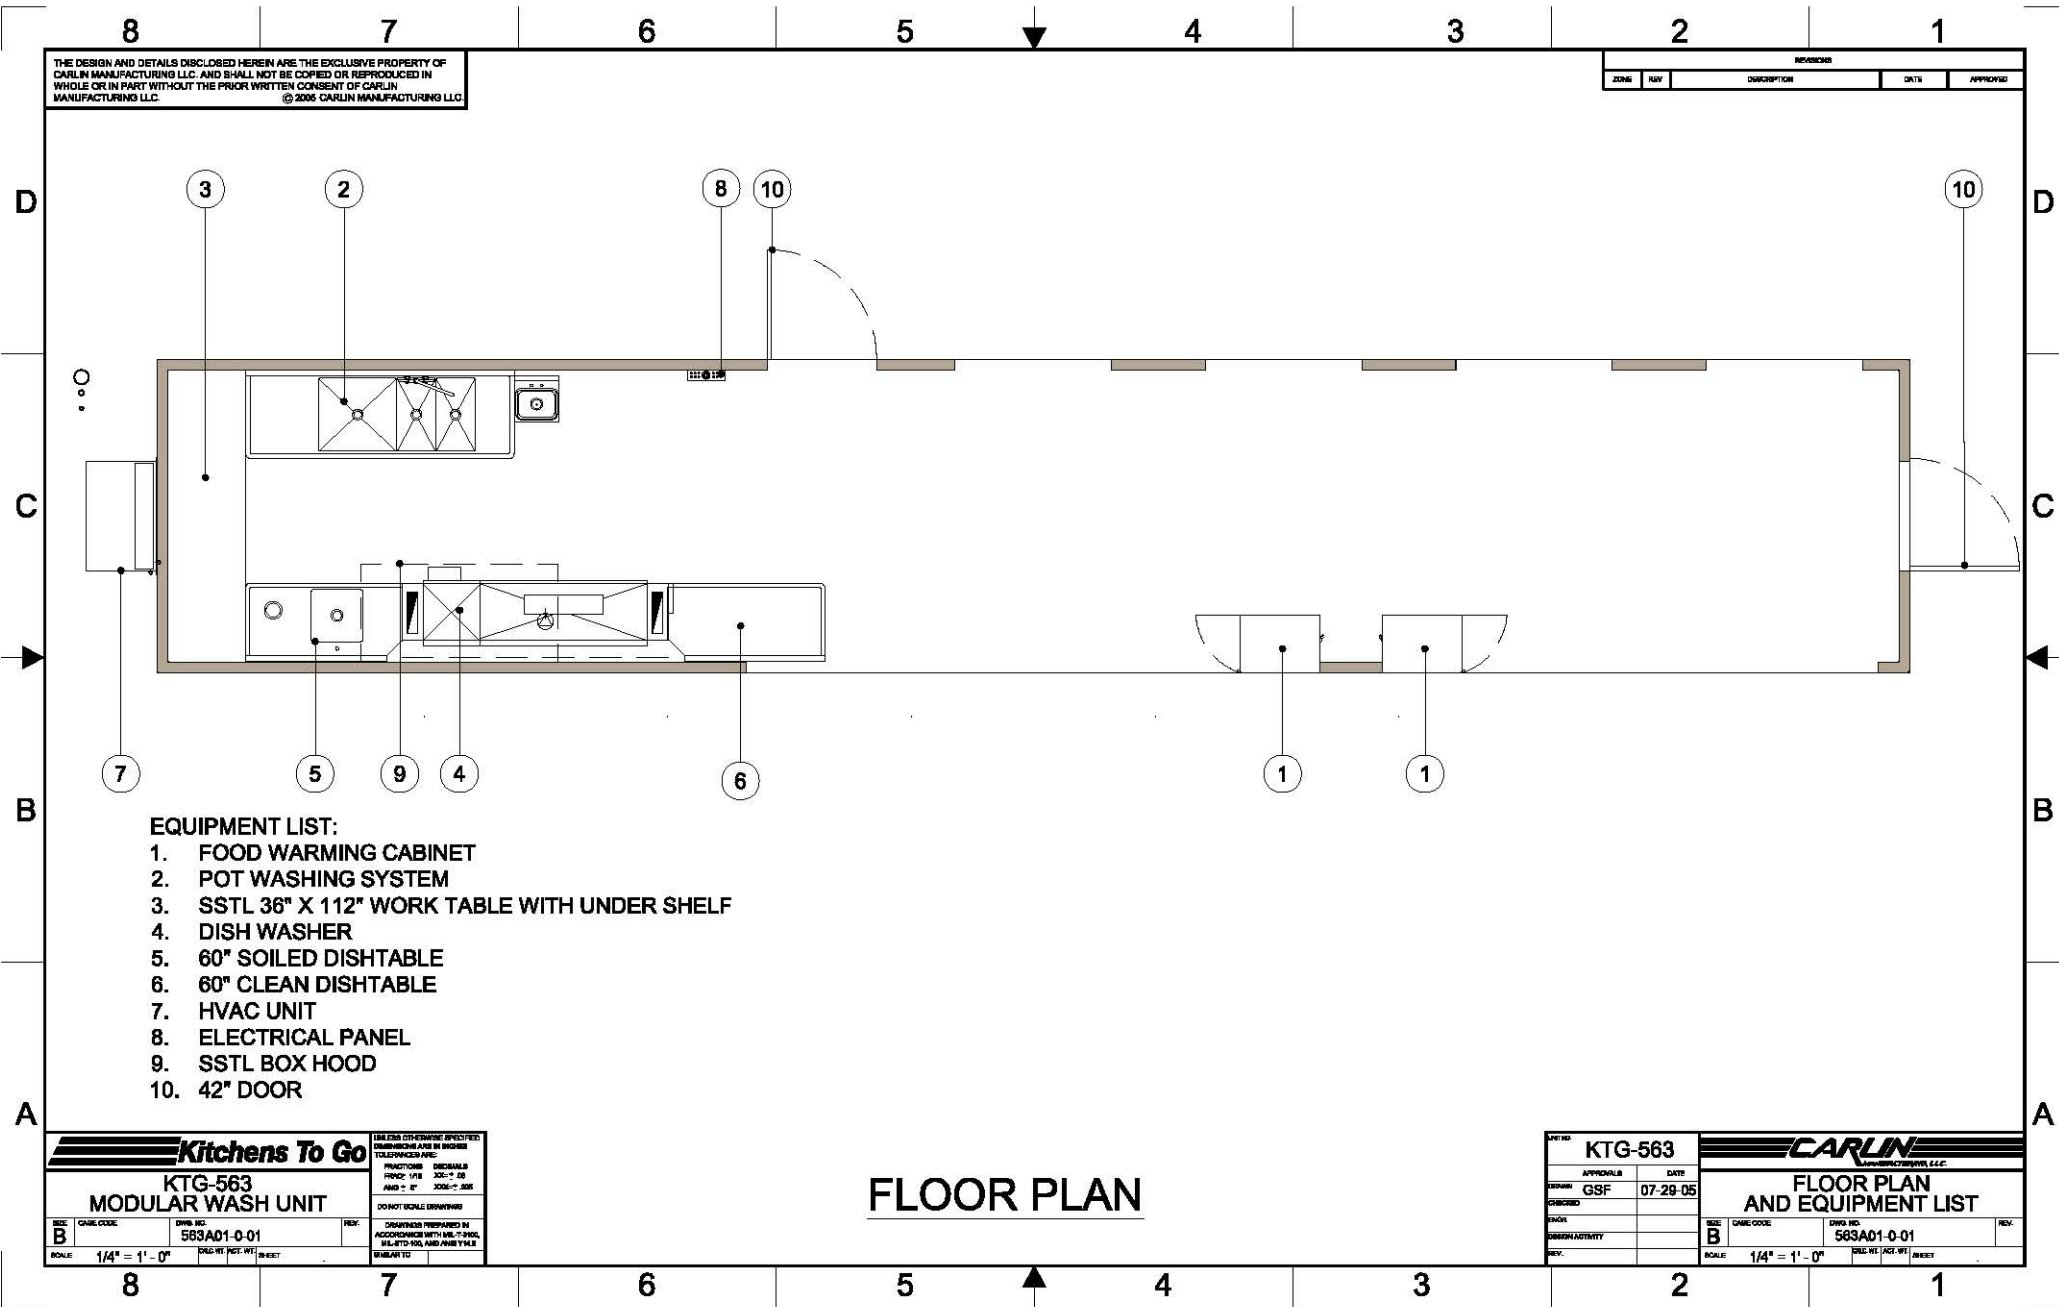

THE DESIGN AND DETAILS DISCLOSED HEREIN ARE THE EXCLUSIVE PROPERTY OF CARLIN MANUFACTURING LLC. AND SHALL NOT BE COPIED OR REPRODUCED IN WHOLE OR IN PART WITHOUT THE PRIOR WRITTEN CONSENT OF CARLIN MANUFACTURING LLC.  
© 2005 CARLIN MANUFACTURING LLC

REVISIONS				
ZONE	REV	DESCRIPTION	DATE	APPROVED

**EQUIPMENT LIST:**

1. FOOD WARMING CABINET
2. POT WASHING SYSTEM
3. SSTL 36" X 112" WORK TABLE WITH UNDER SHELF
4. DISH WASHER
5. 60" SOILED DISHTABLE
6. 60" CLEAN DISHTABLE
7. HVAC UNIT
8. ELECTRICAL PANEL
9. SSTL BOX HOOD
10. 42" DOOR

**Kitchens To Go**  
**KTG-563**  
**MODULAR WASH UNIT**

UNLESS OTHERWISE SPECIFIED DIMENSIONS ARE IN INCHES TOLERANCES ARE:  
 FINISH 1/8" 3/16" 1/4"  
 FRACTIONS DECIMALS  
 1/8" = .125" 3/16" = .1875"  
 1/4" = .25" 1/2" = .50"  
 3/4" = .75" 1" = 1.00"  
 DO NOT SCALE DRAWINGS

DESIGNED AND PREPARED BY: [blank]  
 CHECKED BY: [blank]  
 DRAWN BY: [blank]  
 DATE: 07-29-05  
 SCALE: 1/4" = 1' - 0"

**FLOOR PLAN**

**KTG-563**

APPROVAL: GSF DATE: 07-29-05

**CARLIN**  
 MANUFACTURING LLC

**FLOOR PLAN AND EQUIPMENT LIST**

REV: B DATE: 07-29-05  
 DRAWING NO: 563AD1-0-01  
 SCALE: 1/4" = 1' - 0"