


Please Note: This drawing shows a typical configuration of equipment and does not necessarily show the equipment currently installed in the unit. Verify the specific equipment currently in the unit with a KTG representative.

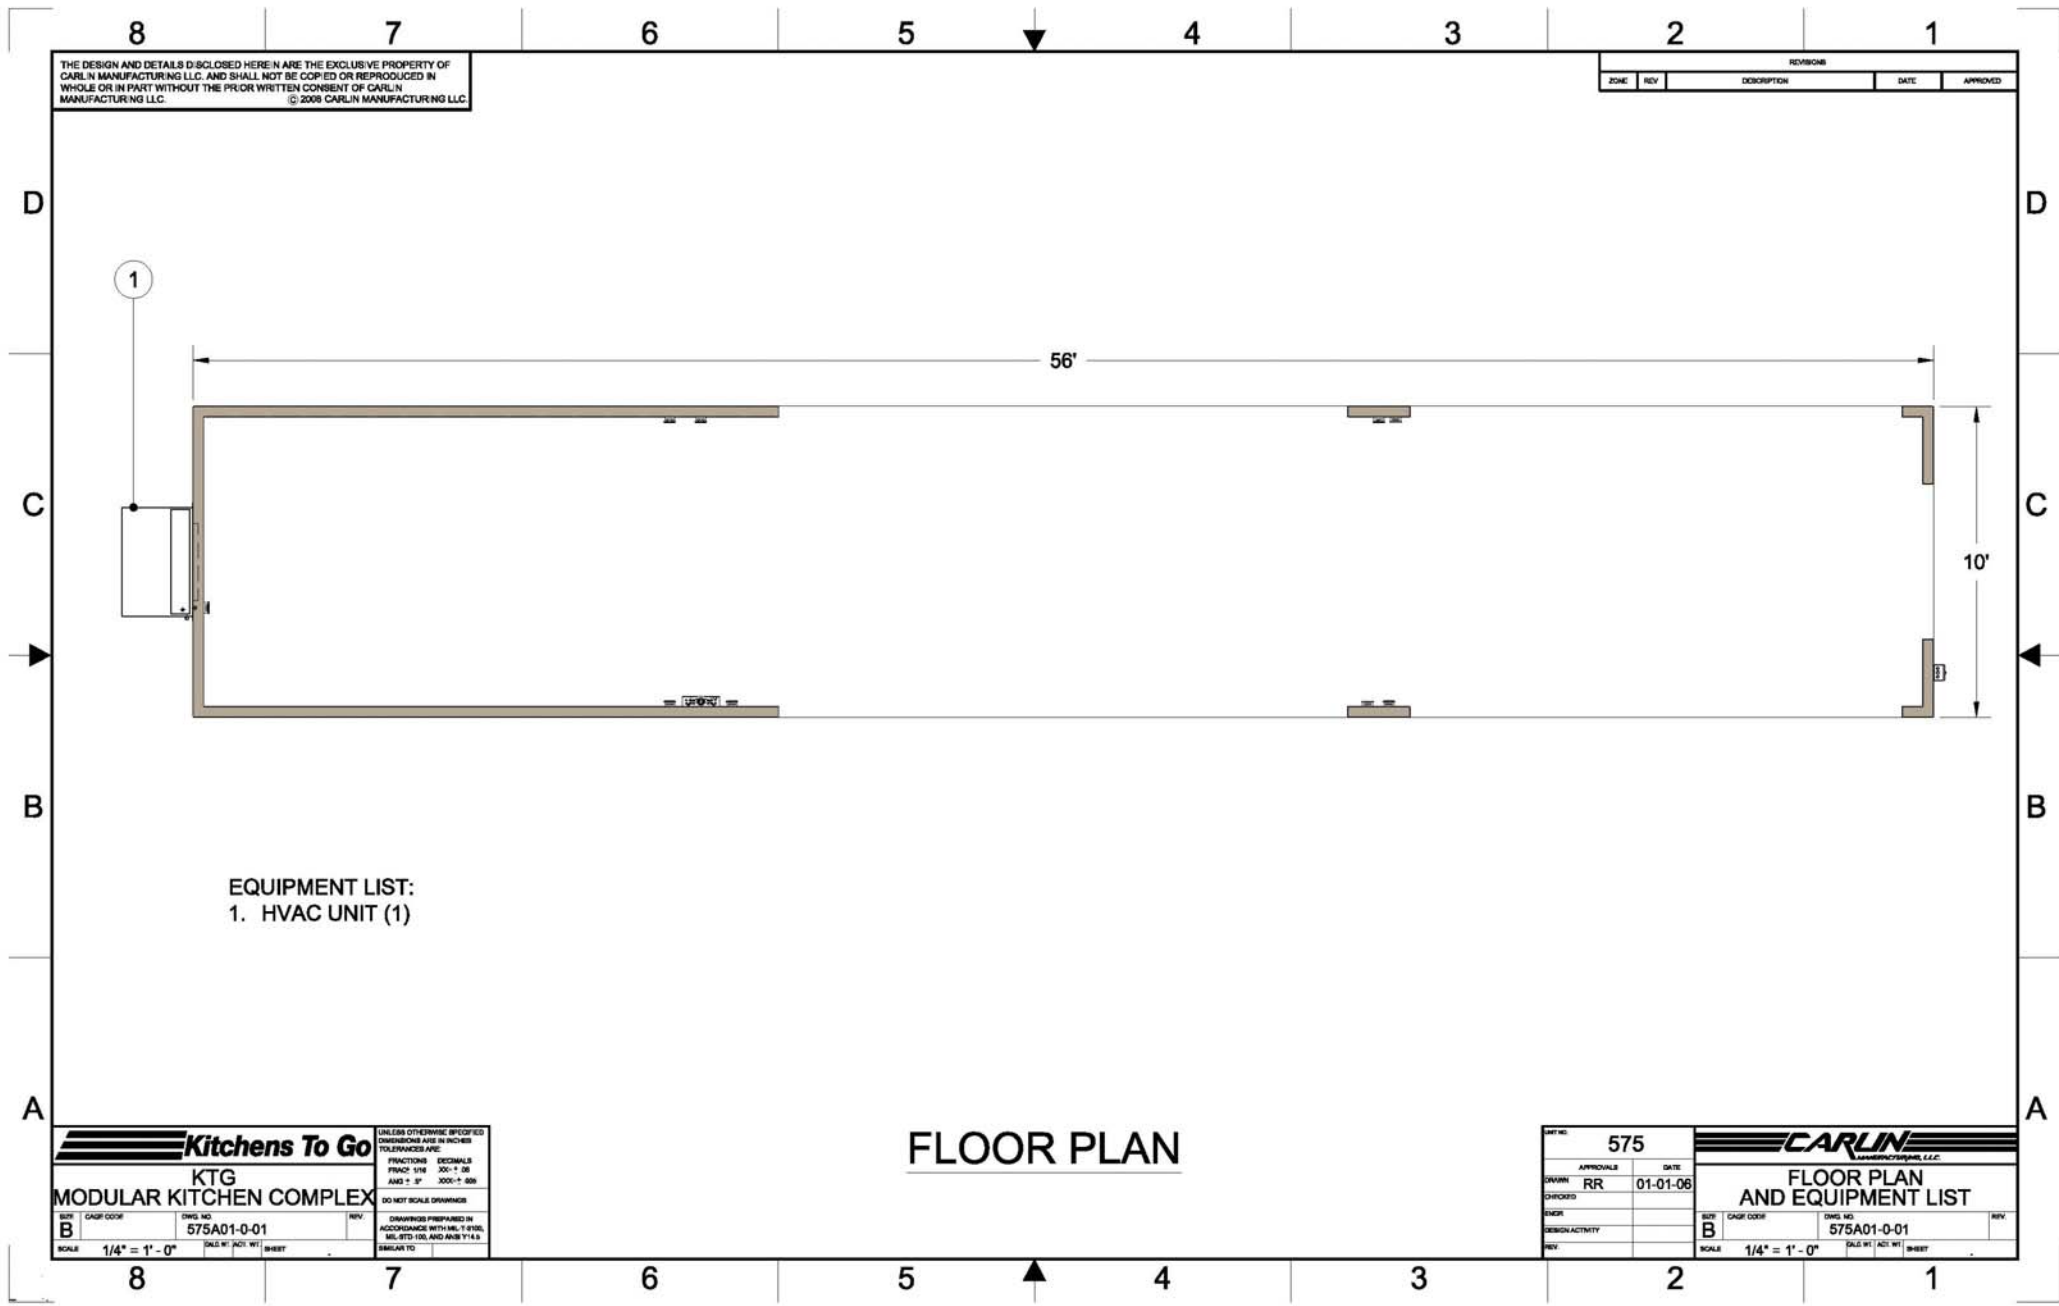

THE DESIGN AND DETAILS DISCLOSED HEREIN ARE THE EXCLUSIVE PROPERTY OF CARLIN MANUFACTURING LLC. AND SHALL NOT BE COPIED OR REPRODUCED IN WHOLE OR IN PART WITHOUT THE PRIOR WRITTEN CONSENT OF CARLIN MANUFACTURING LLC. © 2008 CARLIN MANUFACTURING LLC

REVISIONS				
ZONE	REV	DESCRIPTION	DATE	APPROVED

EQUIPMENT LIST:
1. HVAC UNIT (1)

FLOOR PLAN

Kitchens To Go
KTG
MODULAR KITCHEN COMPLEX

REV	DATE	DESCRIPTION
B	01-01-06	

SCALE: 1/4" = 1'-0"

DWT NO. 575		CARLIN MANUFACTURING LLC	
APPROVALS	DATE	FLOOR PLAN AND EQUIPMENT LIST	
DRAWN RR	01-01-06	REV	
DESIGNED		DWG NO.	575A01-0-01
ENGR		SCALE	1/4" = 1'-0"
DESIGN ACTIVITY		SHEET	
REV			