


Please Note: This drawing shows a typical configuration of equipment and does not necessarily show the equipment currently installed in the unit. Verify the specific equipment currently in the unit with a KTG representative.

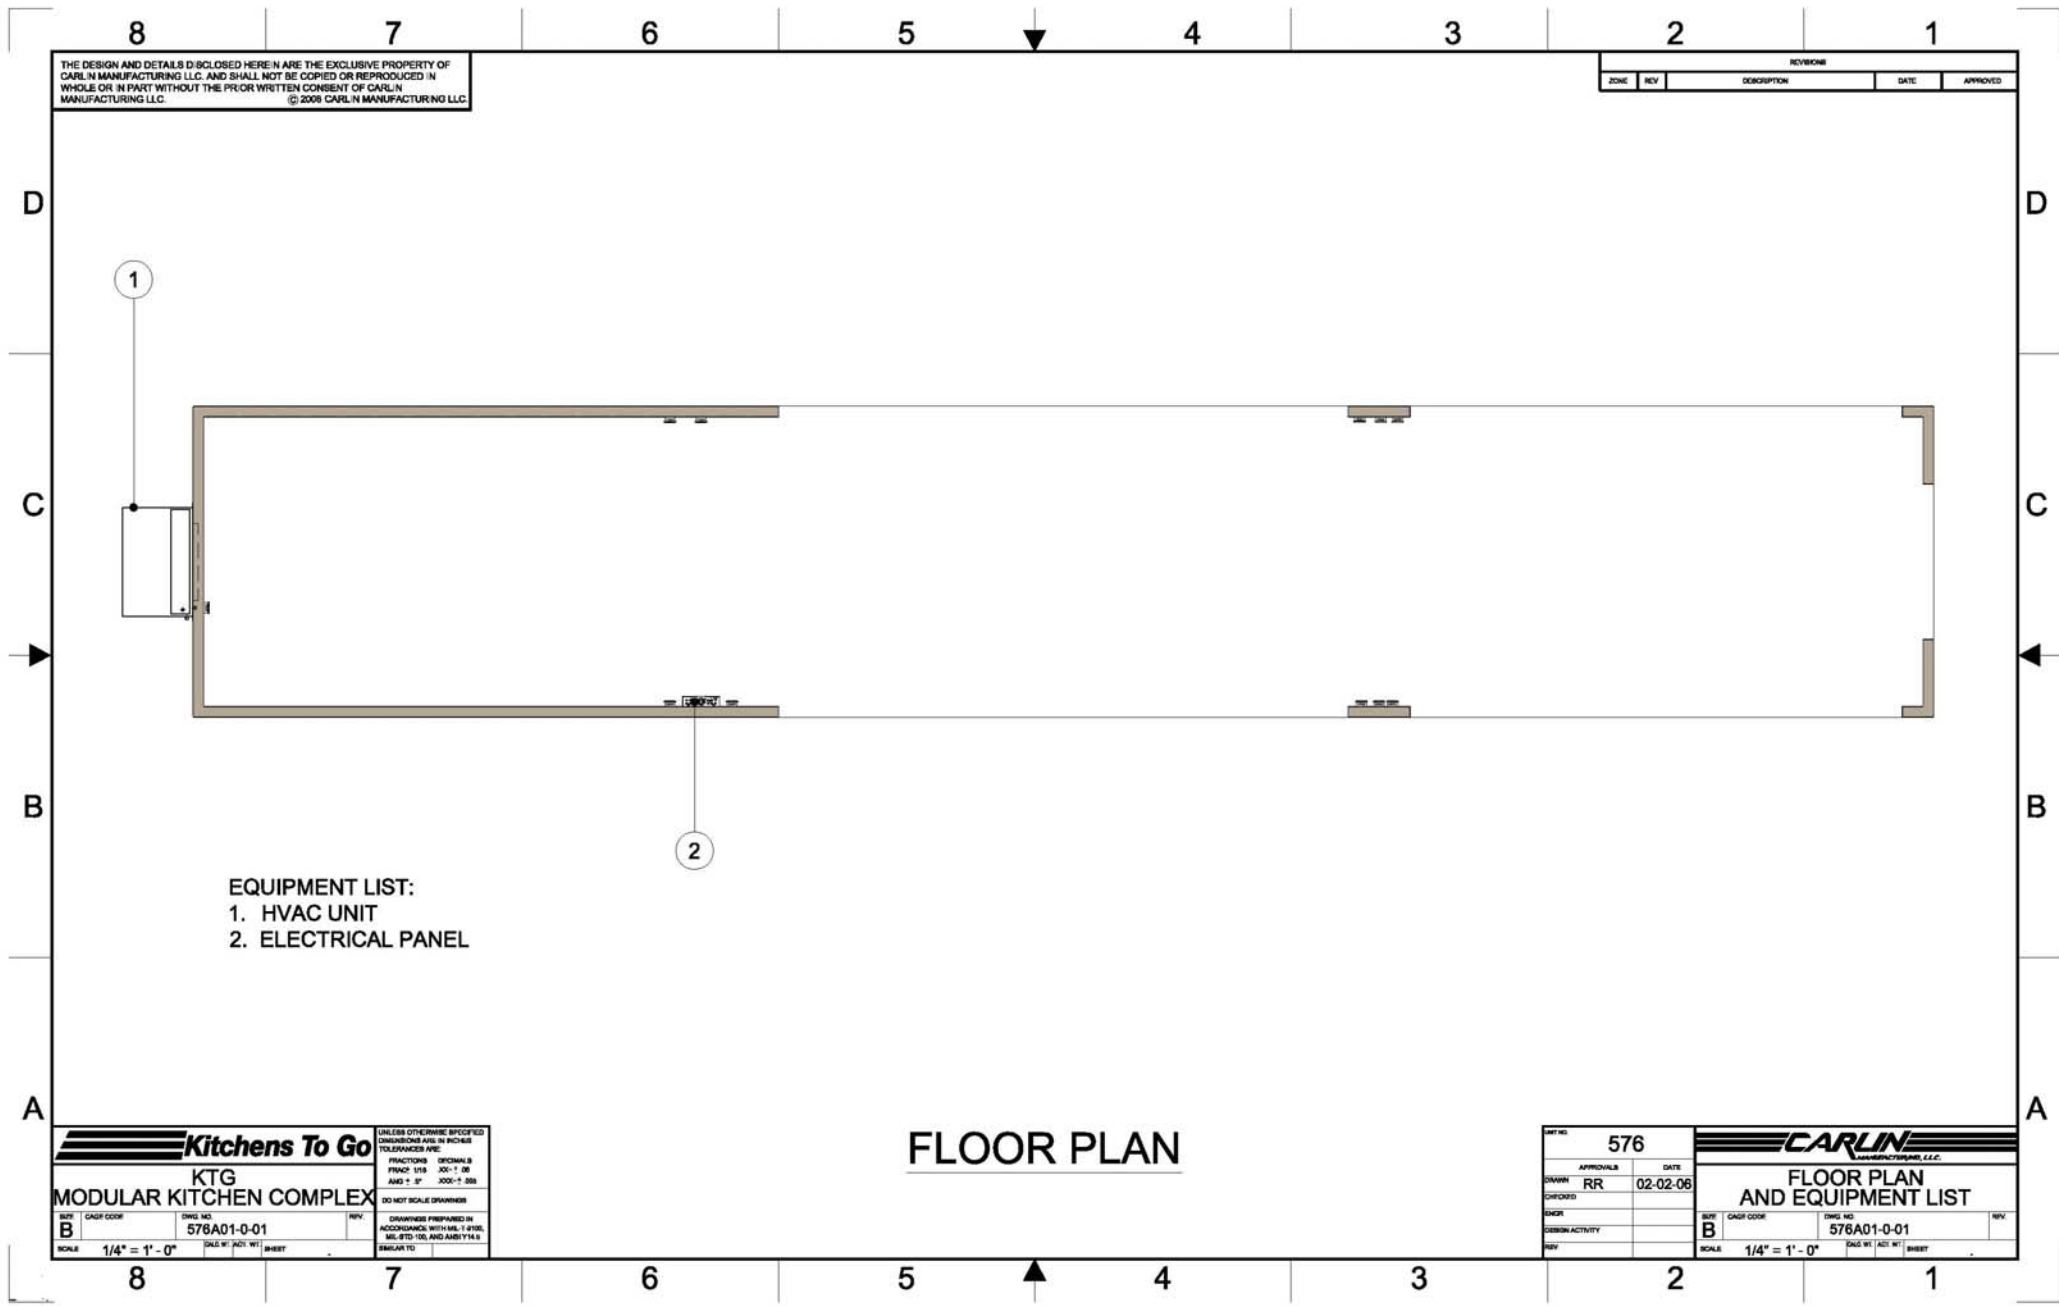

THE DESIGN AND DETAILS DISCLOSED HEREIN ARE THE EXCLUSIVE PROPERTY OF CARLIN MANUFACTURING LLC. AND SHALL NOT BE COPIED OR REPRODUCED IN WHOLE OR IN PART WITHOUT THE PRIOR WRITTEN CONSENT OF CARLIN MANUFACTURING LLC. © 2008 CARLIN MANUFACTURING LLC

REVISIONS				
ZONE	REV	DESCRIPTION	DATE	APPROVED

- EQUIPMENT LIST:**
- HVAC UNIT
 - ELECTRICAL PANEL

Kitchens To Go
KTG
MODULAR KITCHEN COMPLEX

UNLESS OTHERWISE SPECIFIED DIMENSIONS ARE IN INCHES TOLERANCES ARE:
 FRACTIONS DECIMALS
 FINISH 1/16 .001-1.00
 AND 1/8 .002-1.00
 DO NOT SCALE DRAWINGS

DISBURSED PREPARED IN ACCORDANCE WITH MIL-1-8700, MIL-STD-101, AND AMS7145
 SIMILAR TO

SCALE 1/4" = 1'-0"
 SHEET

FLOOR PLAN

DWG NO. 576

APPROVALS DATE 02-02-06

DRAWN RR

CHECKED

ENGR

DESIGN ACTIVITY

REV

CARLIN
 MANUFACTURING, L.L.C.

FLOOR PLAN AND EQUIPMENT LIST

SCALE 1/4" = 1'-0"

DWG NO. 576A01-0-01

SHEET