


Please Note: This drawing shows a typical configuration of equipment and does not necessarily show the equipment currently installed in the unit. Verify the specific equipment currently in the unit with a KTG representative.

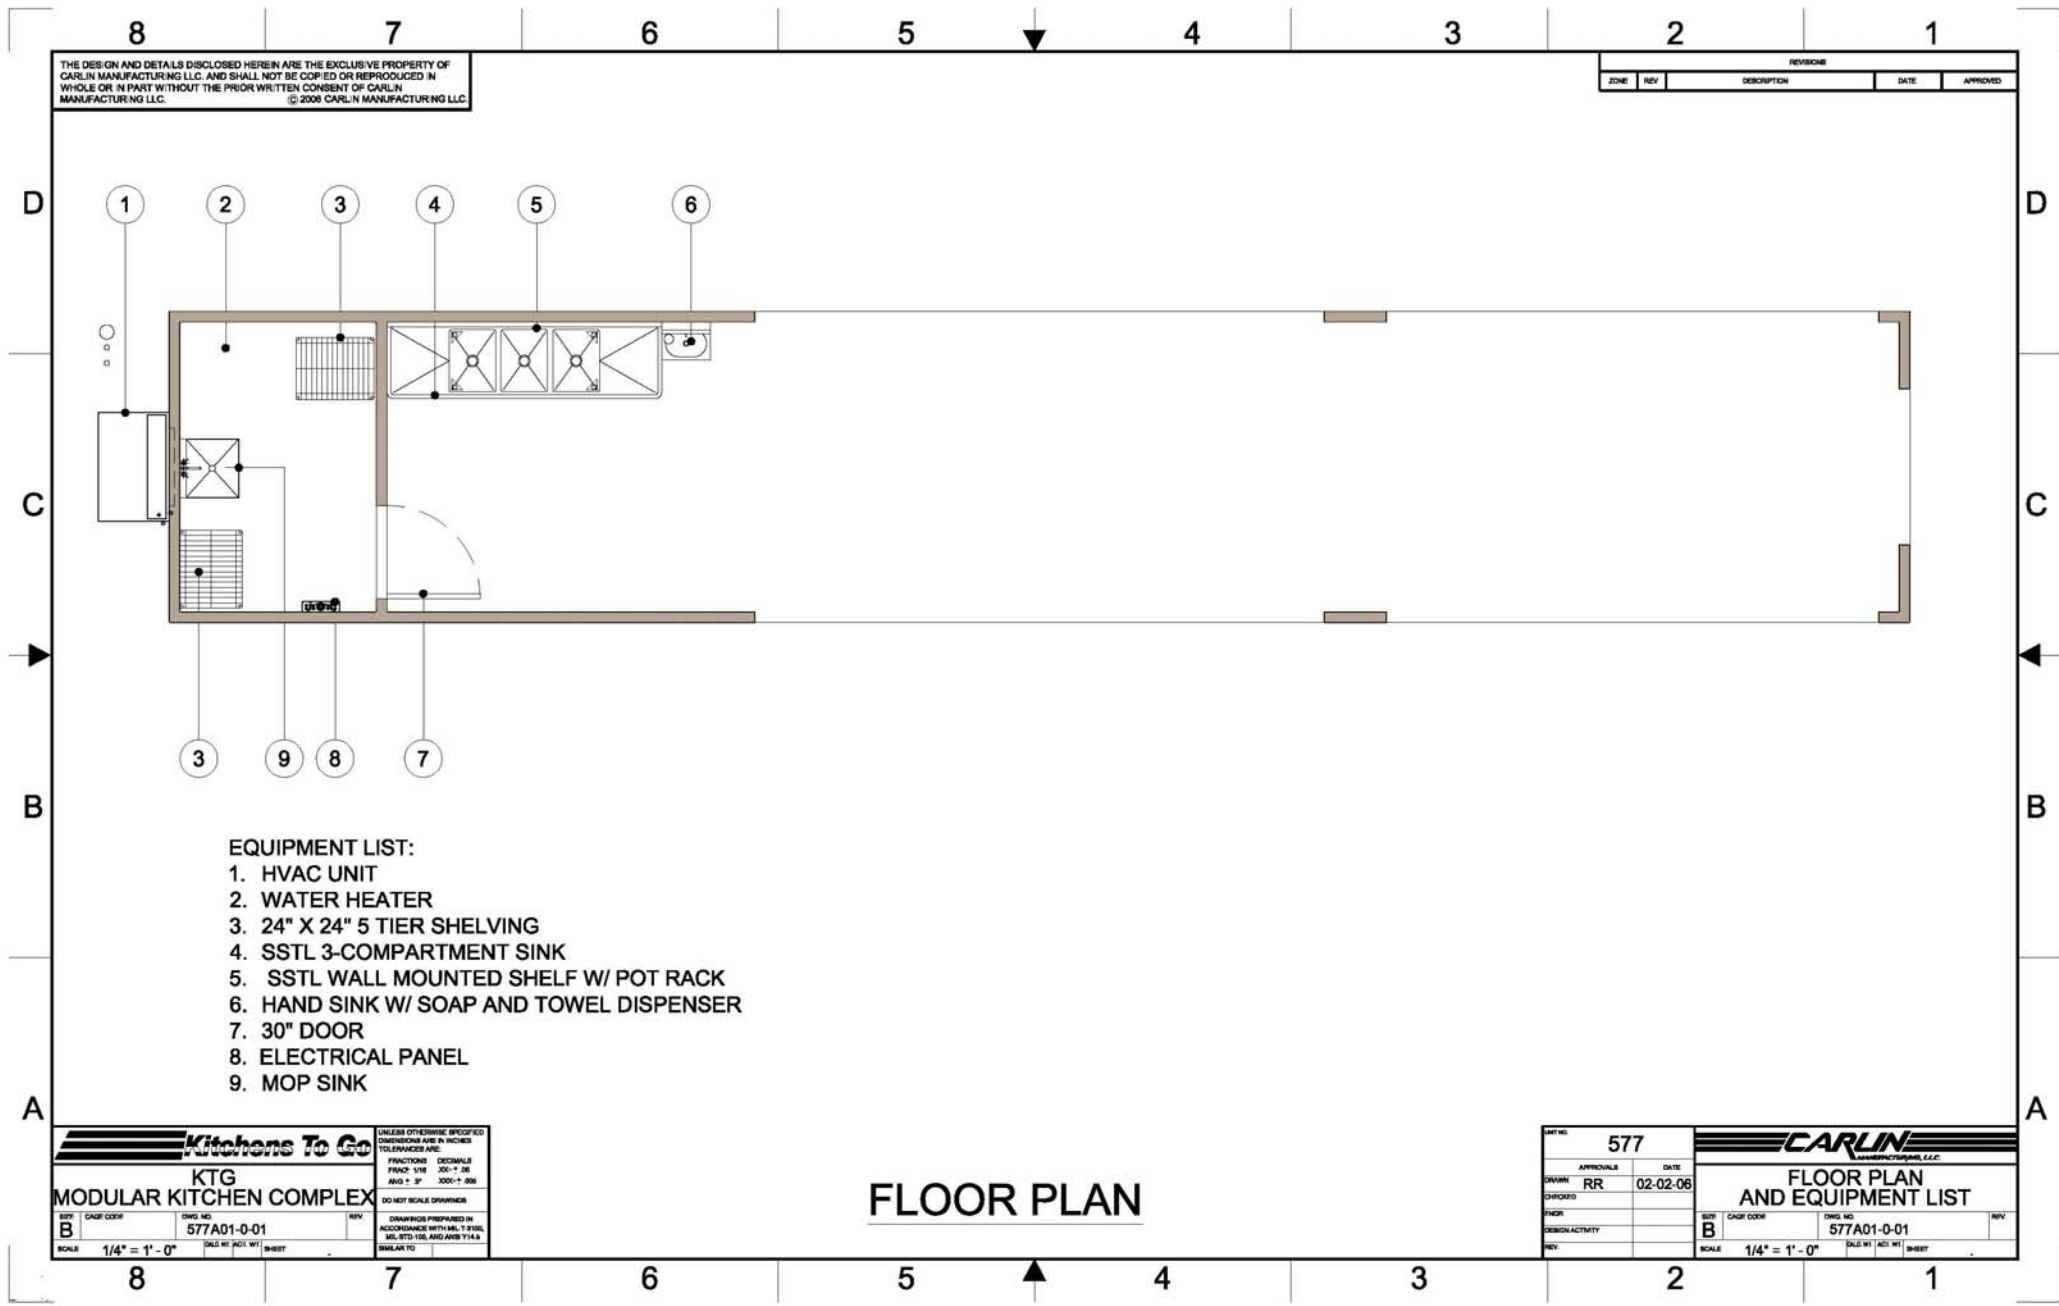

THE DESIGN AND DETAILS DISCLOSED HEREIN ARE THE EXCLUSIVE PROPERTY OF CARLIN MANUFACTURING LLC. AND SHALL NOT BE COPIED OR REPRODUCED IN WHOLE OR IN PART WITHOUT THE PRIOR WRITTEN CONSENT OF CARLIN MANUFACTURING LLC. © 2008 CARLIN MANUFACTURING LLC.

REVISIONS				
ZONE	REV	DESCRIPTION	DATE	APPROVED

- EQUIPMENT LIST:**
1. HVAC UNIT
 2. WATER HEATER
 3. 24" X 24" 5 TIER SHELVING
 4. SSSL 3-COMPARTMENT SINK
 5. SSSL WALL MOUNTED SHELF W/ POT RACK
 6. HAND SINK W/ SOAP AND TOWEL DISPENSER
 7. 30" DOOR
 8. ELECTRICAL PANEL
 9. MOP SINK

Kitchens To Go		UNLESS OTHERWISE SPECIFIED DIMENSIONS ARE IN INCHES TOLERANCES ARE:	
KTG MODULAR KITCHEN COMPLEX		FRACTIONS: DECIMALS	
DWG NO. 577A01-0-01		FINISH: 1/8"	300" ± .05
SCALE: 1/4" = 1'-0"		AND: 1/4"	3000" ± .05
DO NOT SCALE DRAWINGS		DISABLER PREPARED IN ACCORDANCE WITH MIL-1-9366, MIL-STD-105 AND ANSI Y14.5	
SIMILAR TO			

FLOOR PLAN

DWG NO. 577		CARLIN	
APPROVALS	DATE	FLOOR PLAN AND EQUIPMENT LIST	
DRAWN: RR	02-02-06		
DESIGNED			
ENGR			
DESIGN ACTIVITY			
REV			
SCALE: 1/4" = 1'-0"		DWG NO. 577A01-0-01	
SHEET		SHEET	